


FED. ROAD DIST. No.	STATE	FEDERAL PROJ. NO.	FISCAL YEAR	SHEET No.	TOTAL SHEETS


PLAN	SURVEYED	DATE
	PLOTTED	
NOTE BOOK NO.	CHECKED	
	BY	

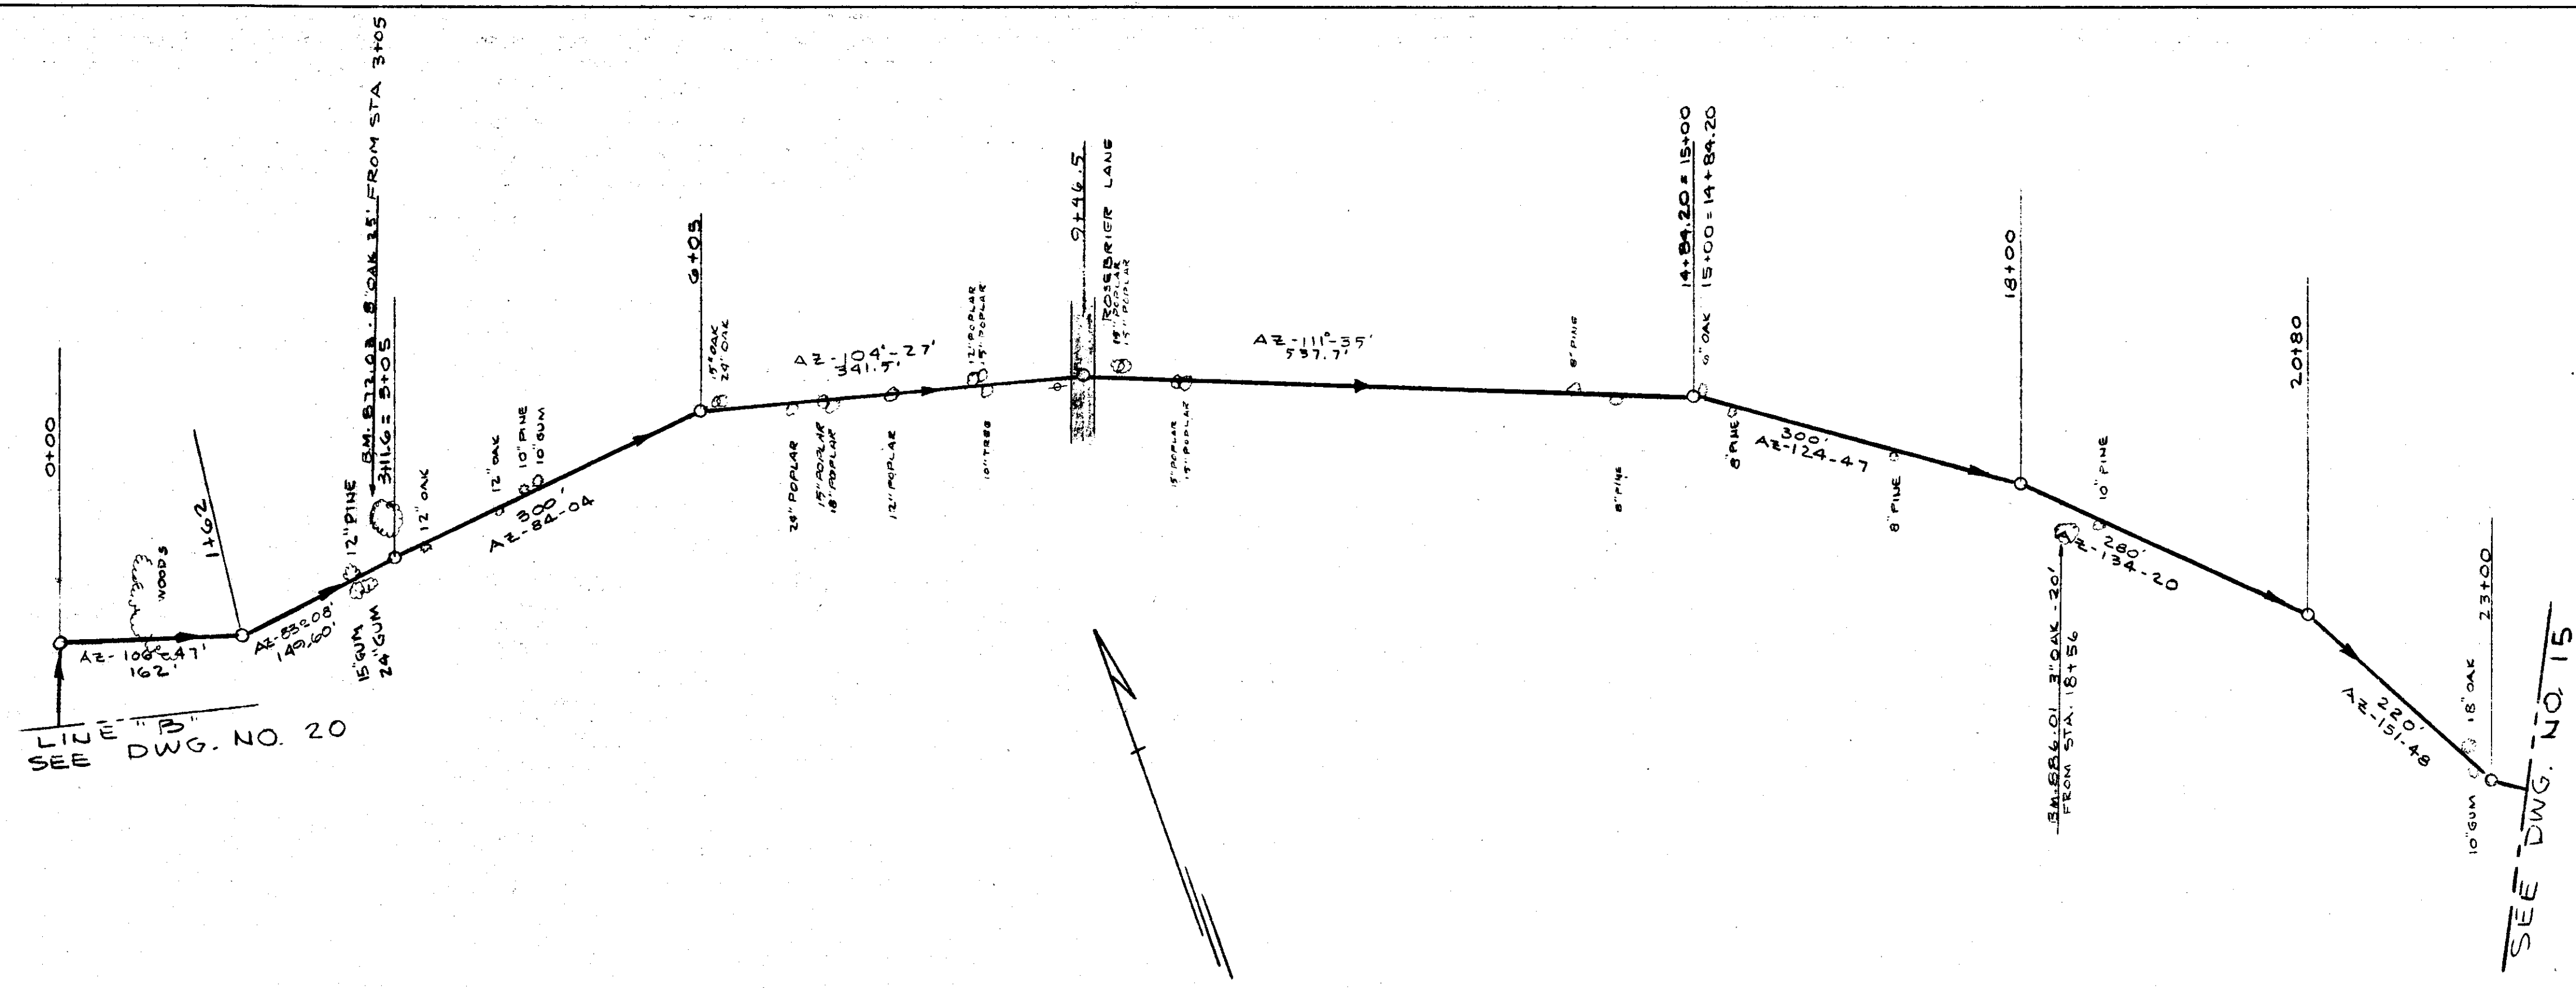

NO.	DATE	BY	REVISIONS
2	11-22-63	RD	REVISED PLAN
1	9-22-63	RD	GENERAL

OUTFALL LINE  
 WADE HAMPTON WATER AND SEWER DISTRICT  
 GREENVILLE COUNTY, S. C.  
**PLAN AND PROFILE**  
**TRUNK SYSTEM**  
 PIEDMONT ENGINEERING SERVICE  
 GREENVILLE, S. C.  
 DRAWN BY \_\_\_\_\_ CHECKED BY \_\_\_\_\_ DATE \_\_\_\_\_  
 JULY 1963 DWG. NO. 16

PROFILE	SURVEYED	DATE
	PLOTTED	
NOTE BOOK NO.	CHECKED	
	BY	

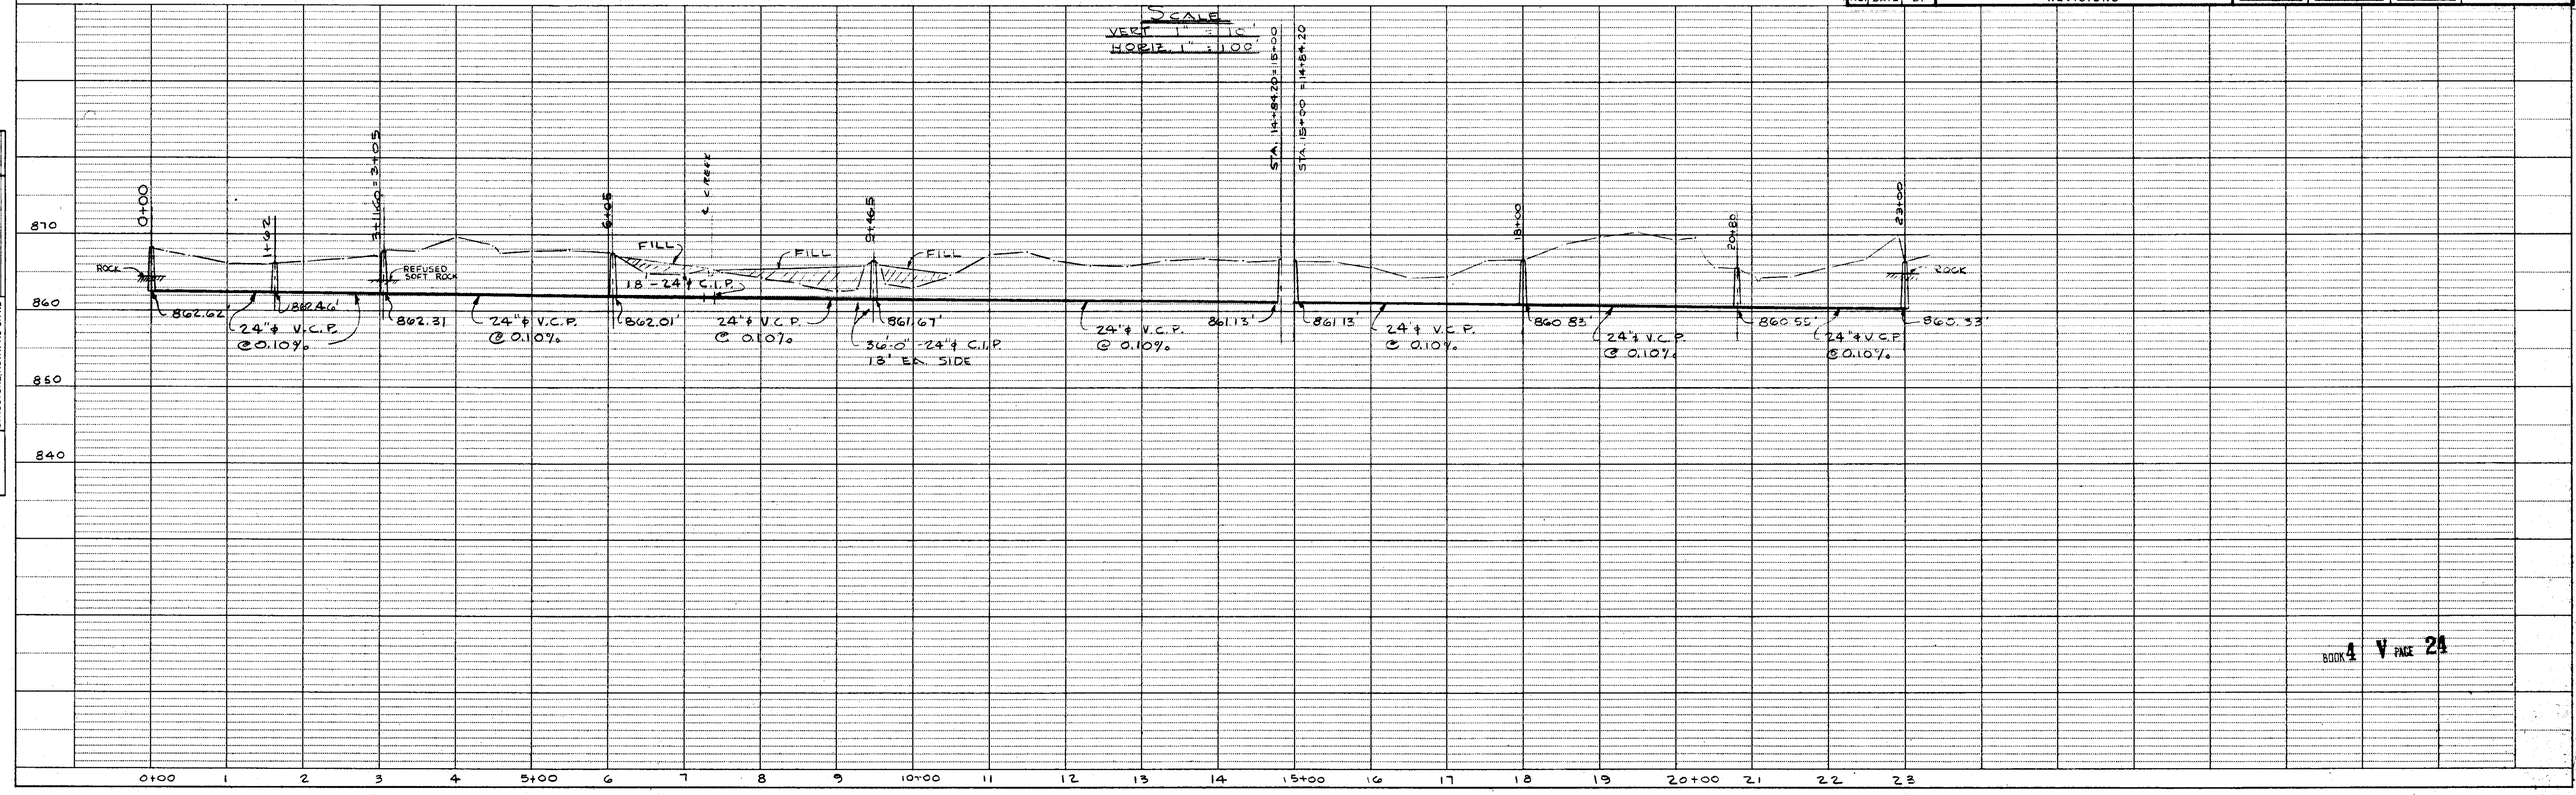

SINGLE PLAN AND PROFILE - DOTTED  
 H. A. ROGERS CO. - MINNEAPOLIS - ST. PAUL - DULUTH