



FED. ROAD DIST. NO.	STATE	FEDERAL PROJ. NO.	FISCAL YEAR	SHEET NO.	TOTAL SHEETS

PLAN	DATE
SURVEYED	
ALIGNED	
CHECKED	
NOTE BOOK NO.	
BY	

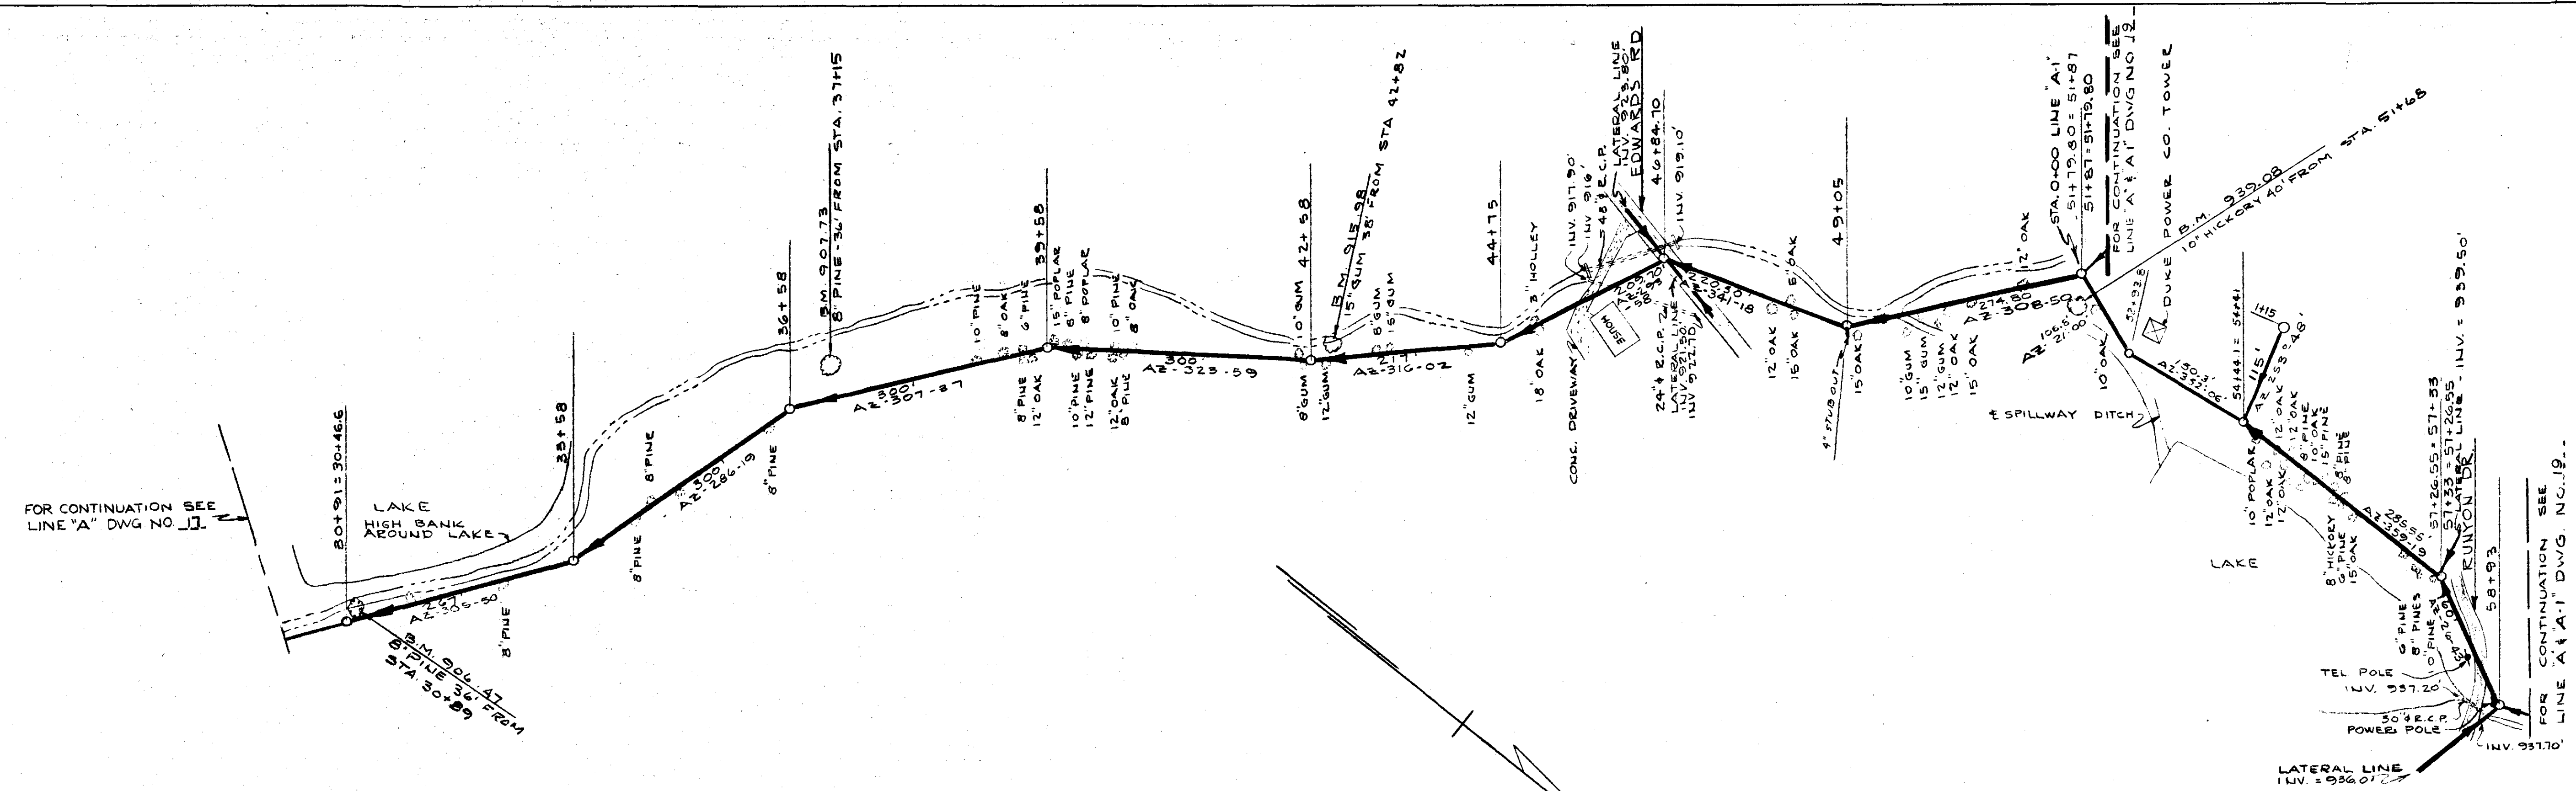

WADE HAMPTON WATER AND SEWER DISTRICT GREENVILLE COUNTY, S. C.	
<b>PLAN AND PROFILE TRUNK SYSTEM</b>	
PIEDMONT ENGINEERING SERVICE GREENVILLE, S. C.	
NO. DATE BY	REVISIONS
2 10-24-63 JML	REVISED PLAN, PROFILE STA. 31+79.8 - 51+44.1
1 8-14-63 JML	GENERAL
NO. DATE BY	REVISIONS
DRAWN BY	CHECKED BY
DATE	DATE
	JULY 1963
	DWG. NO. 18

PROFILE	DATE
SURVEYED	
GRADES CHECKED	
NOTE BOOK NO.	
BY	

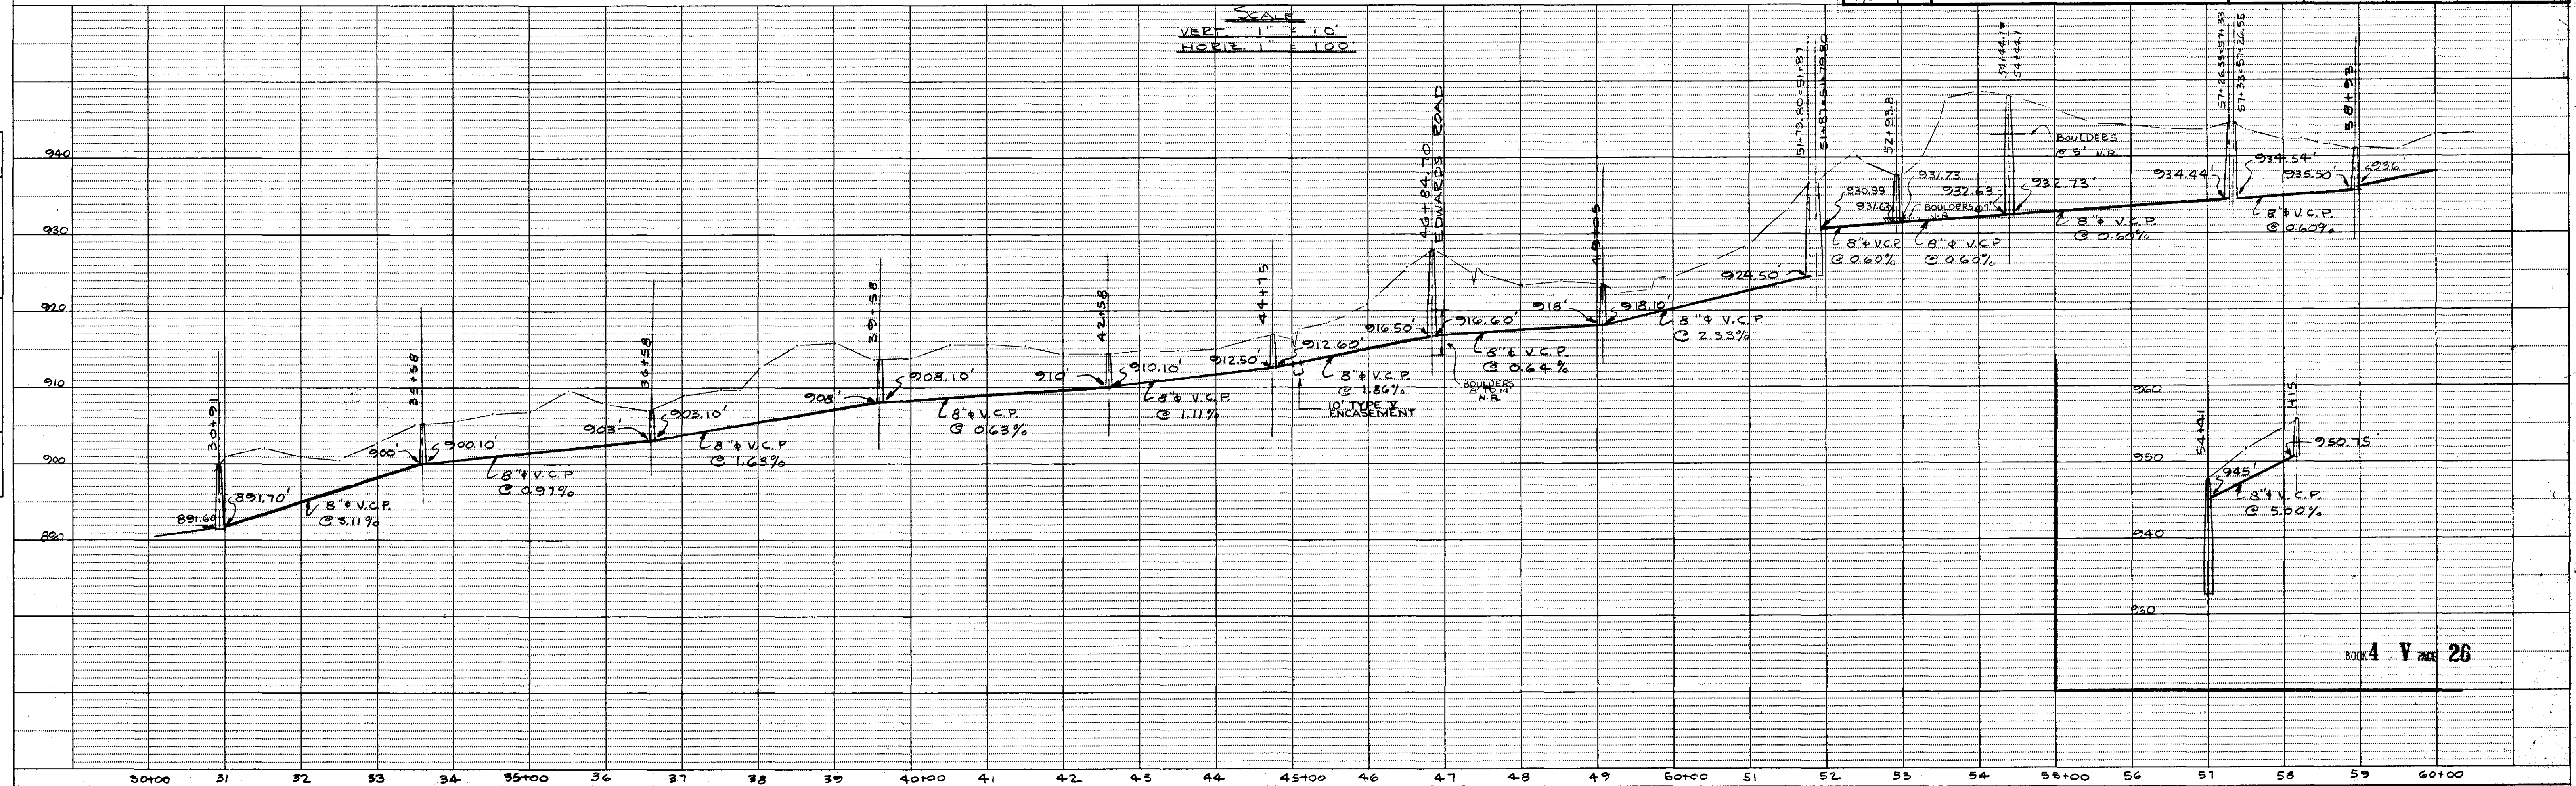

SINGLE PLAN AND PROFILE - DOTTED  
H. A. ROGERS CO., MINNEAPOLIS - ST. PAUL - DULUTH