



DATE	
BY	
SURVEYED	
PLOTTED	
CHECKED	
NOTE BOOK	
NO.	

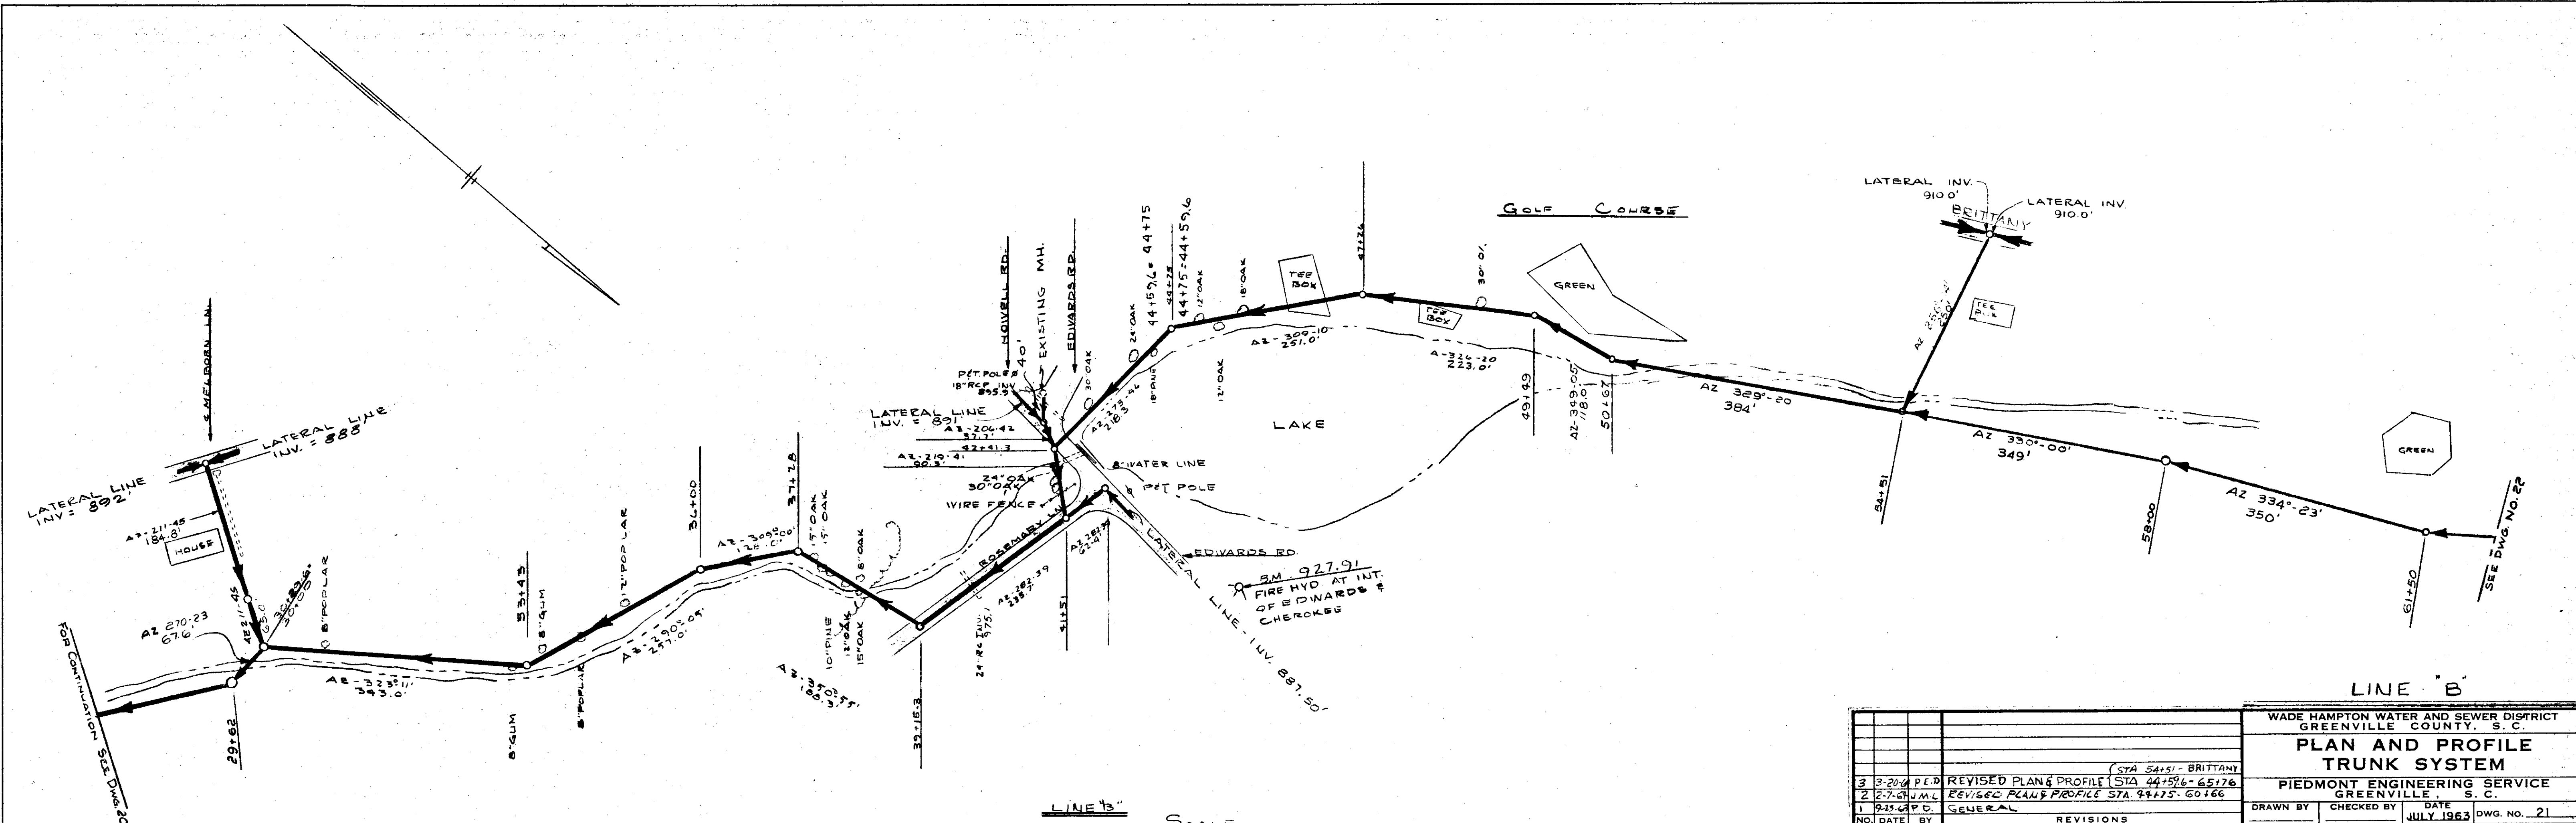

WADE HAMPTON WATER AND SEWER DISTRICT GREENVILLE COUNTY, S. C.	
PLAN AND PROFILE TRUNK SYSTEM	
3-30-64 P.E.D.	REVISED PLAN & PROFILE (STA 44+51.6 - 65+76)
2-27-64 J.M.L.	REVISED PLAN & PROFILE (STA 44+51.6 - 60+66)
1-25-64 P.D.	GENERAL
NO. DATE BY	REVISIONS
DRAWN BY: _____ CHECKED BY: _____ DATE: JULY 1963 DWG. NO. 21	

DATE	
BY	
SURVEYED	
PLOTTED	
CHECKED	
NOTE BOOK	
NO.	

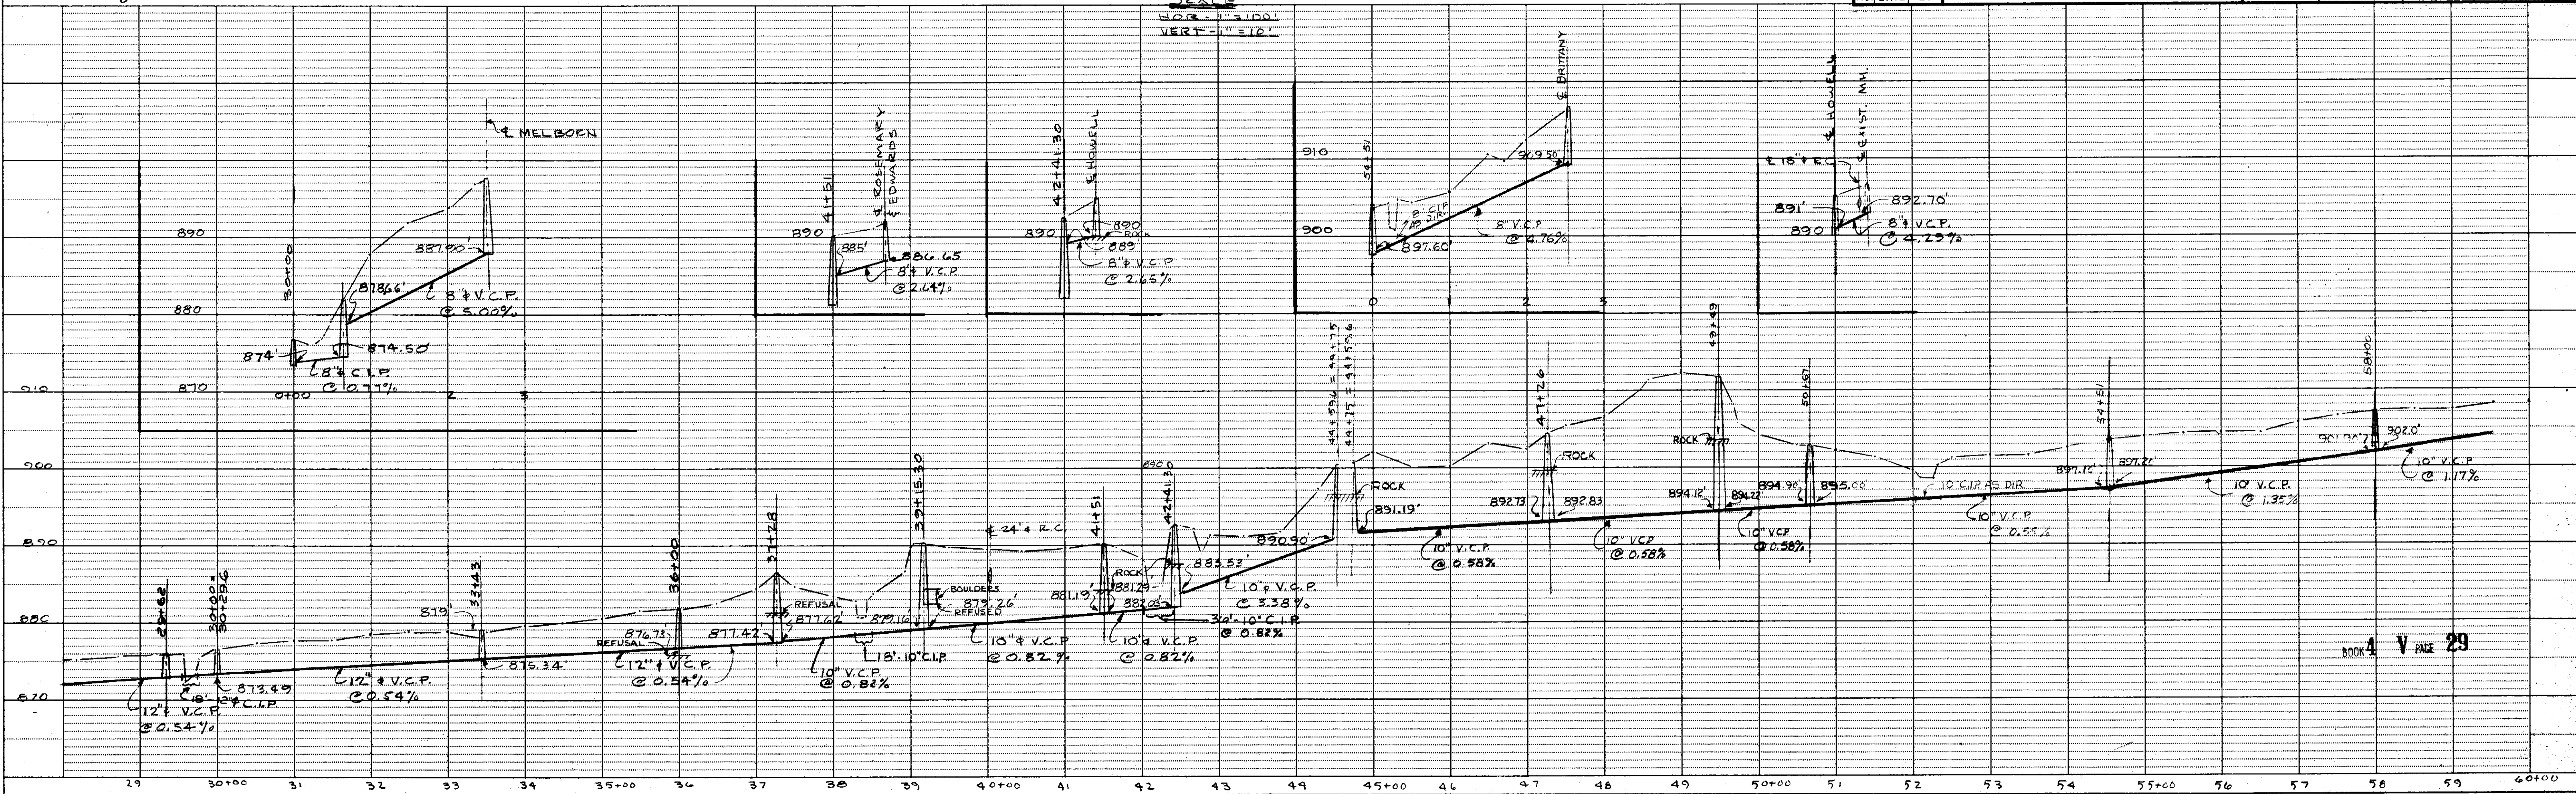

SINGLE PLAN AND PROFILE - DOTTED
N. A. ROGERS CO. - MINNEAPOLIS - ST. PAUL - DULUTH