



FED. ROAD DIST. No.	STATE	FEDERAL PROJ. NO.	FISCAL YEAR	SHEET No.	TOTAL SHEETS

PLAN	DATE
SURVEYED	
PLOTTED	
NOTED	
CHECKED	
RE. OF WAY CHECKED	
NO.	

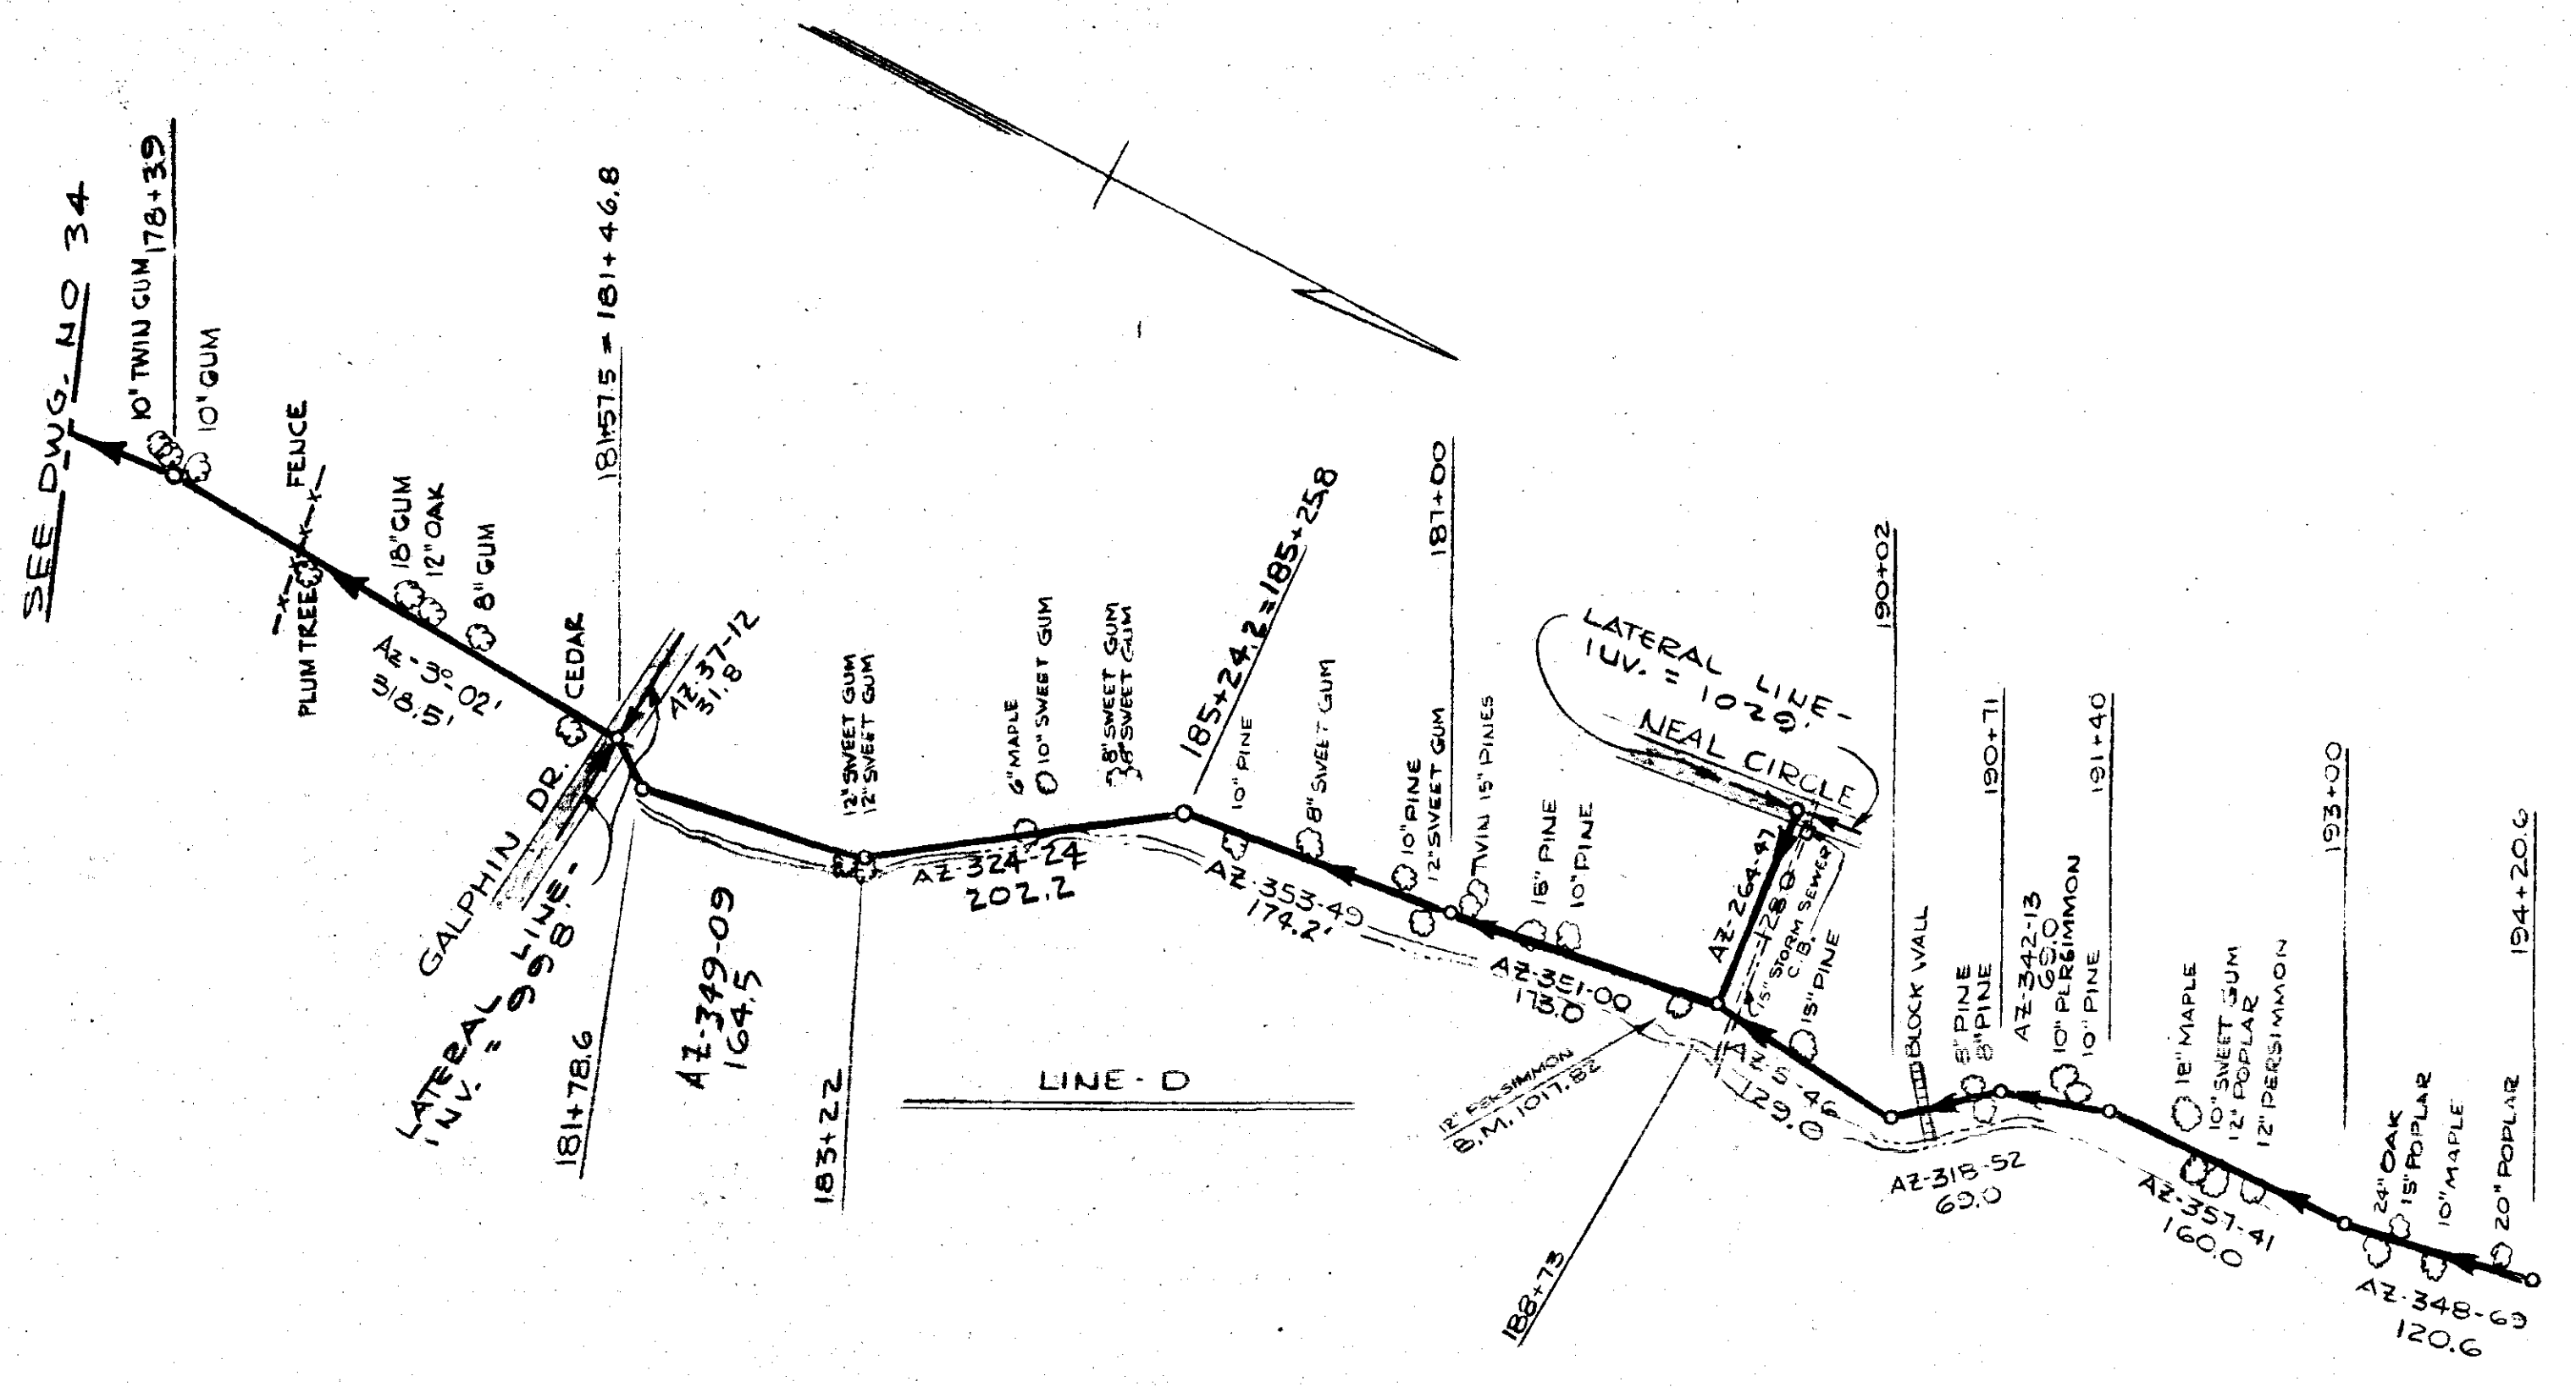

PROFILE	DATE
SURVEYED	
GRADES CHECKED	
NOTED	
STRUCTURE NOTATIONS OK'D	
NO.	

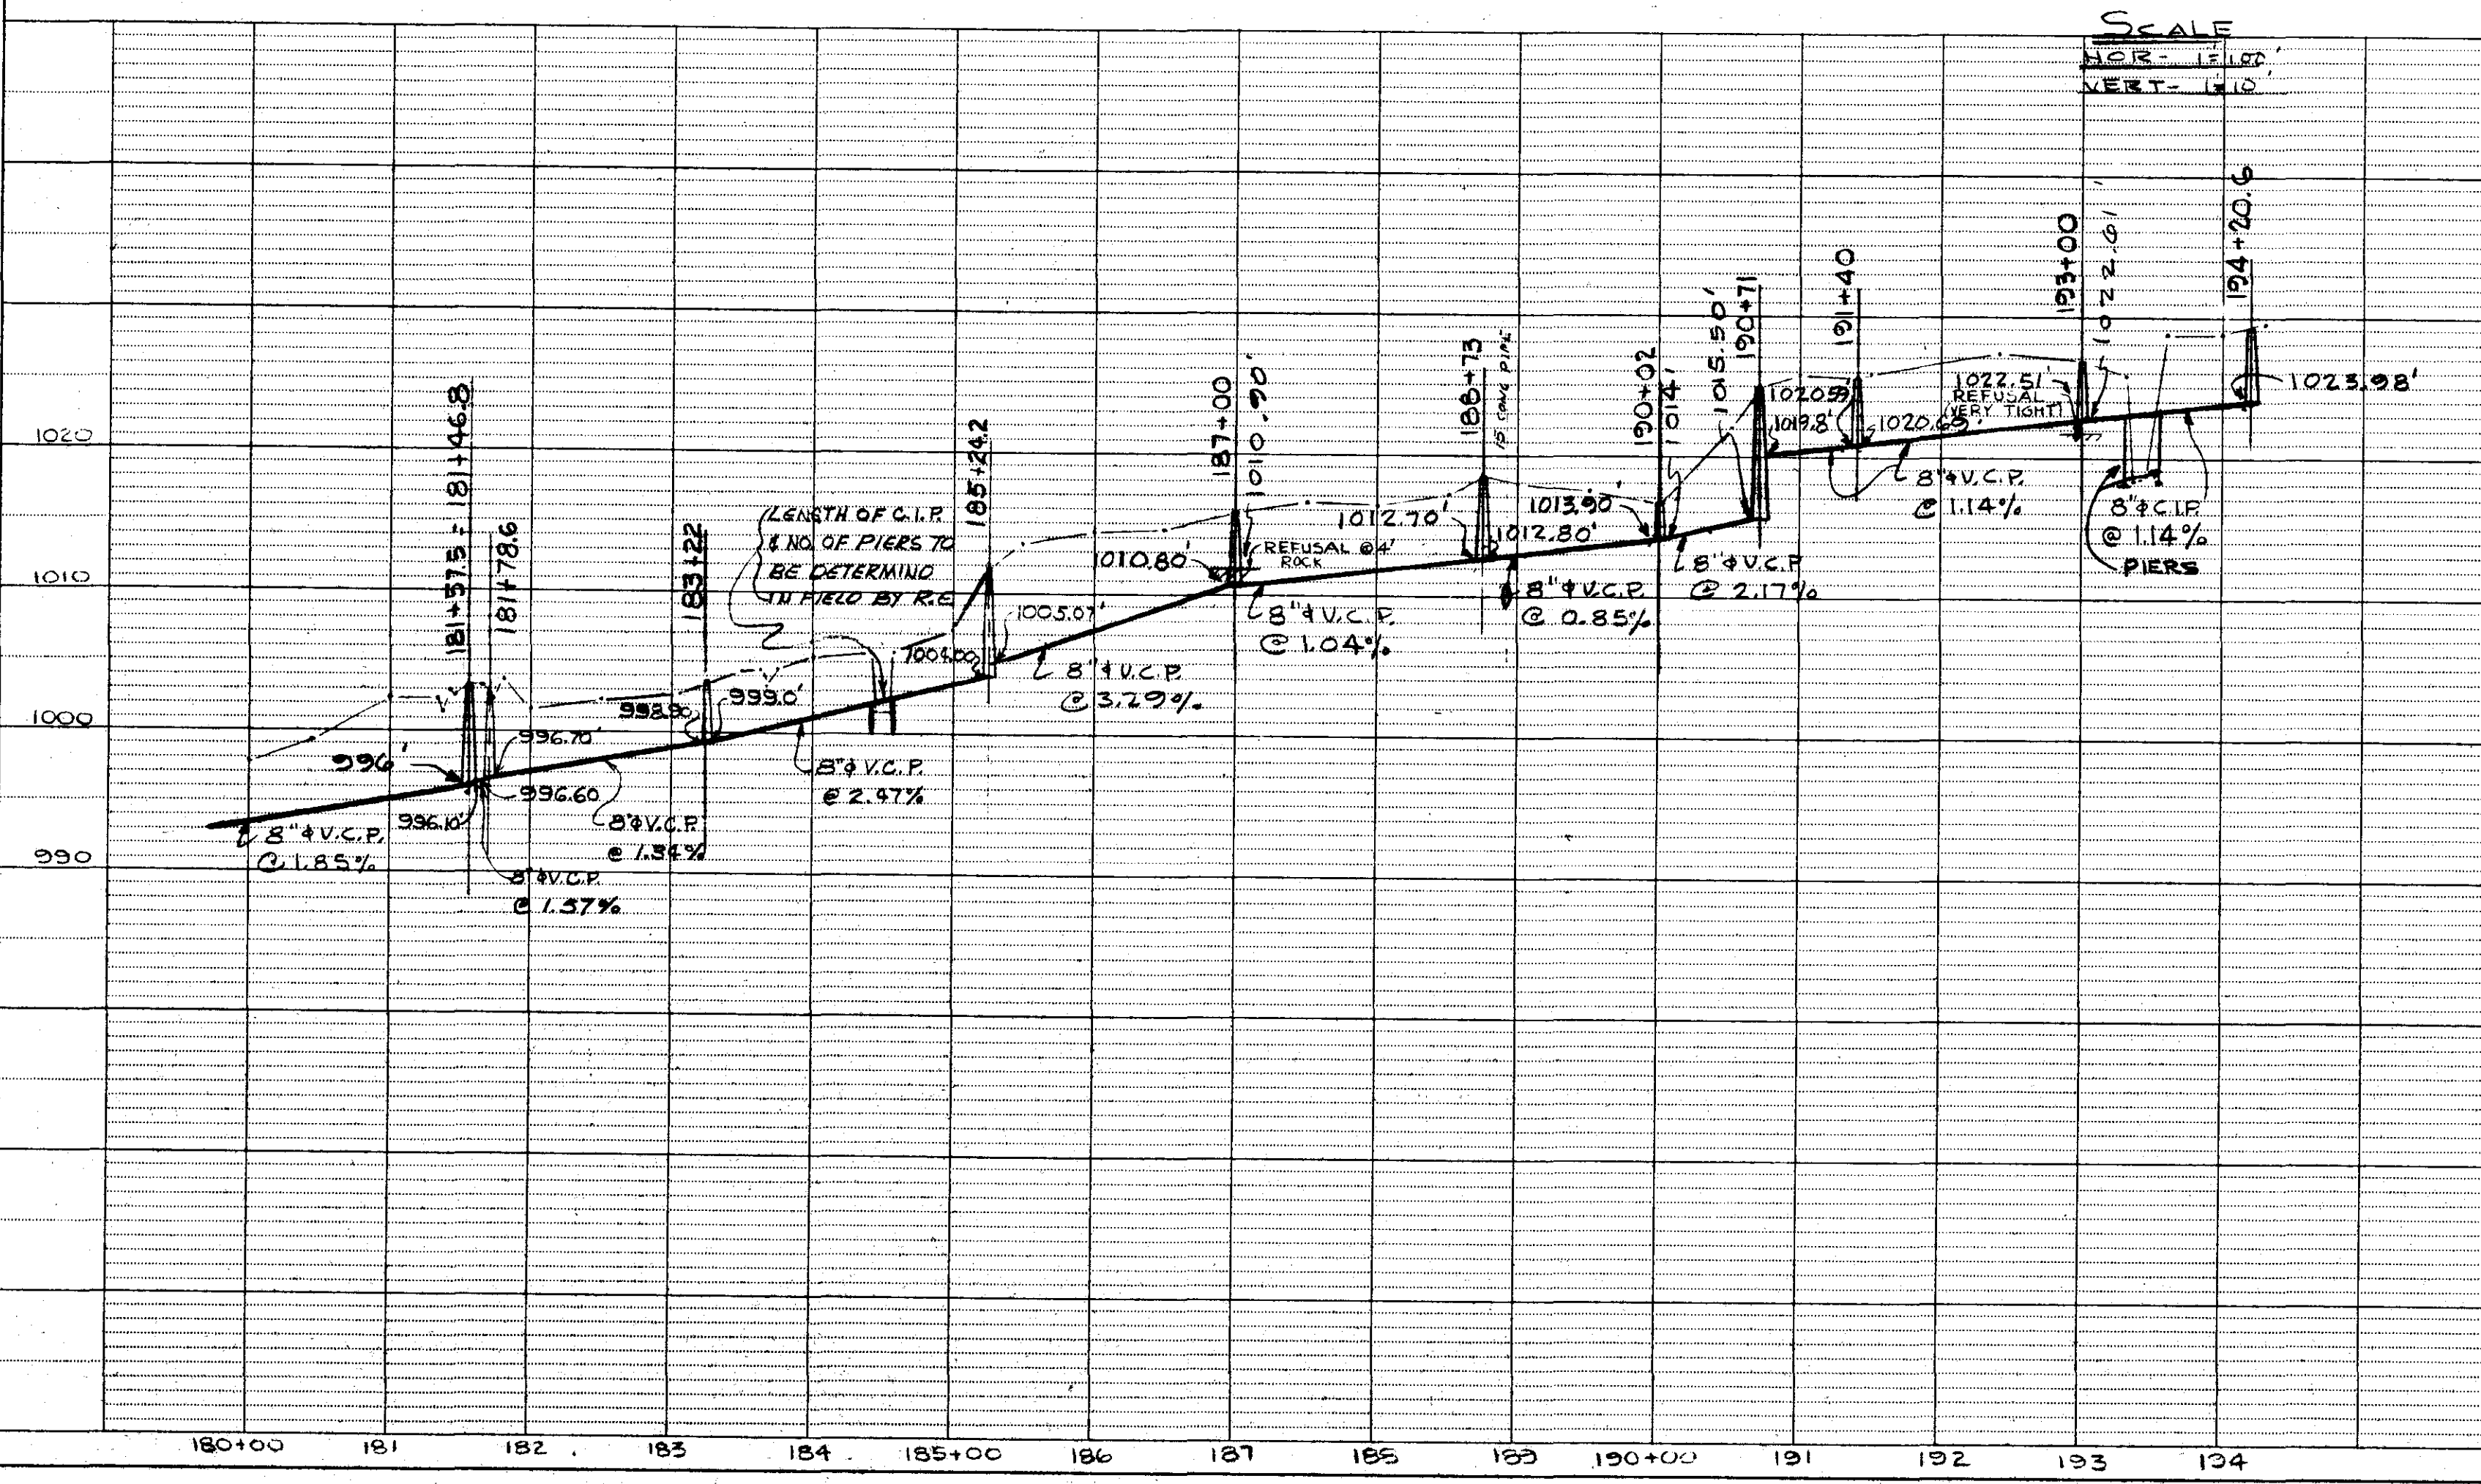

WADE HAMPTON WATER AND SEWER DISTRICT GREENVILLE COUNTY, S. C.	
PLAN AND PROFILE TRUNK SYSTEM	
PIEDMONT ENGINEERING SERVICE GREENVILLE, S. C.	
NO.	DATE
3	11-1-64
2	4-10-64
1	12-23-63
BY	REVISIONS
	FIELD REVISION - ADD 18\"/>

DRAWN BY	CHECKED BY	DATE	DWG. NO.
		JULY 1963	35