


BOOK 4 V PAGE 117

PROFILE


REVISIONS	
NO.	DATE BY DESCRIPTION
1	7-24-72 R.C. REVISED LINE IN W. BULTER AVE

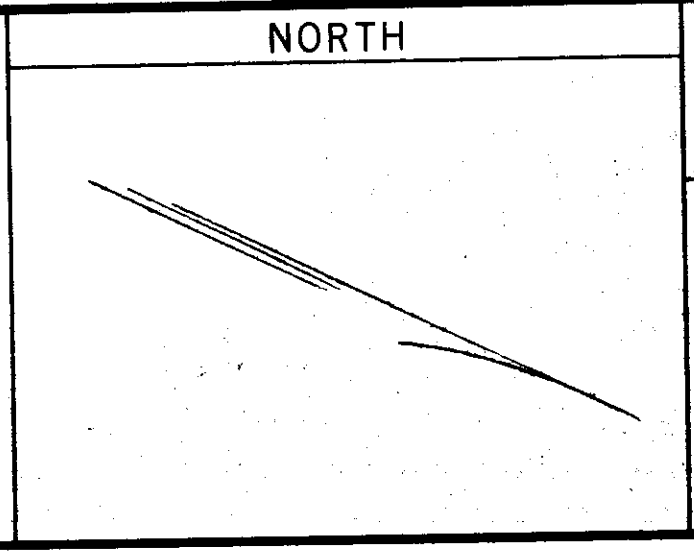

SCALE

HORIZONTALLY
1" = 100'

VERTICALLY
1" = 10'

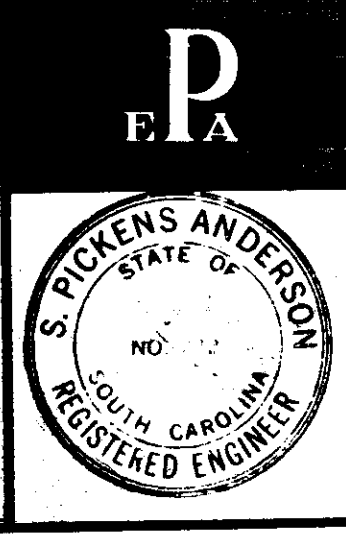

TOWN OF MAULDIN
GREENVILLE COUNTY, S.C.
MAPLE CREEK BASIN
SANITARY SEWERS

PLAN AND PROFILE
INTERCEPTOR SYSTEM

PIEDMONT
ENGINEERS & ARCHITECTS
420 PARK AVE., GREENVILLE, S.C.

SHEET NO.	13-A
DWN R.L.C.	
CKD P.E.D.	
APPD	
JOB 20020	
DATE 6-30-67	