



NO.	DATE	BY	REVISIONS DESCRIPTION

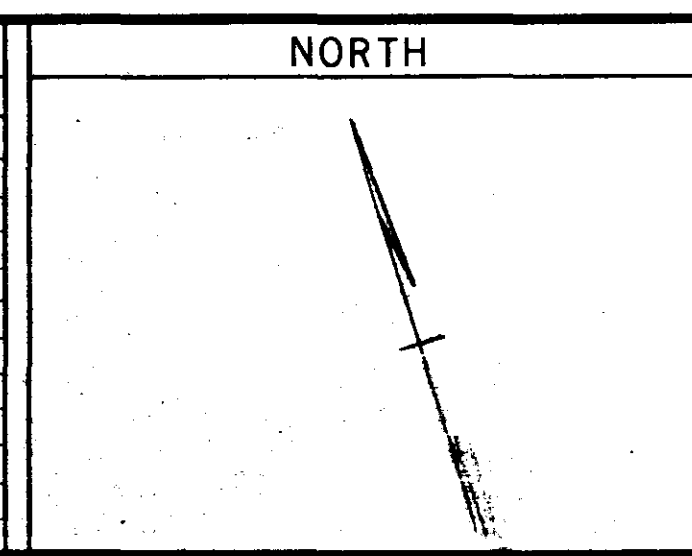

SCALE

HORIZONTALLY
1" = 100'

VERTICALLY
1" = 10'

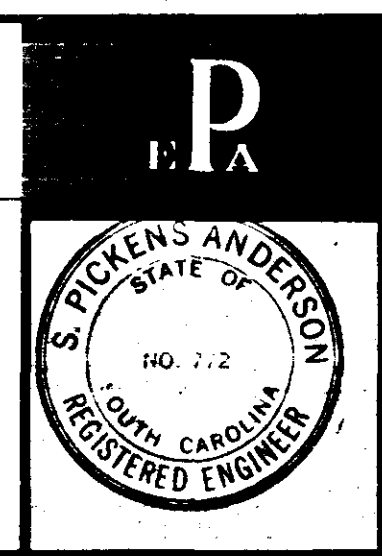

TOWN OF MAULDIN
GREENVILLE COUNTY, S.C.
GILDER CREEK BASIN
SANITARY SEWERS

PLAN AND PROFILE
INTERCEPTOR SYSTEM

PIEDMONT
ENGINEERS & ARCHITECTS
420 PARK AVE., GREENVILLE, S.C.

BOOK 4 V PAGE 125
LINE 6

SHEET NO.
29

DWN R.L.C.
CKD P.E.D.
APPD
JOB 20020
DATE 4-24-67