


## INDEX TO DRAWINGS

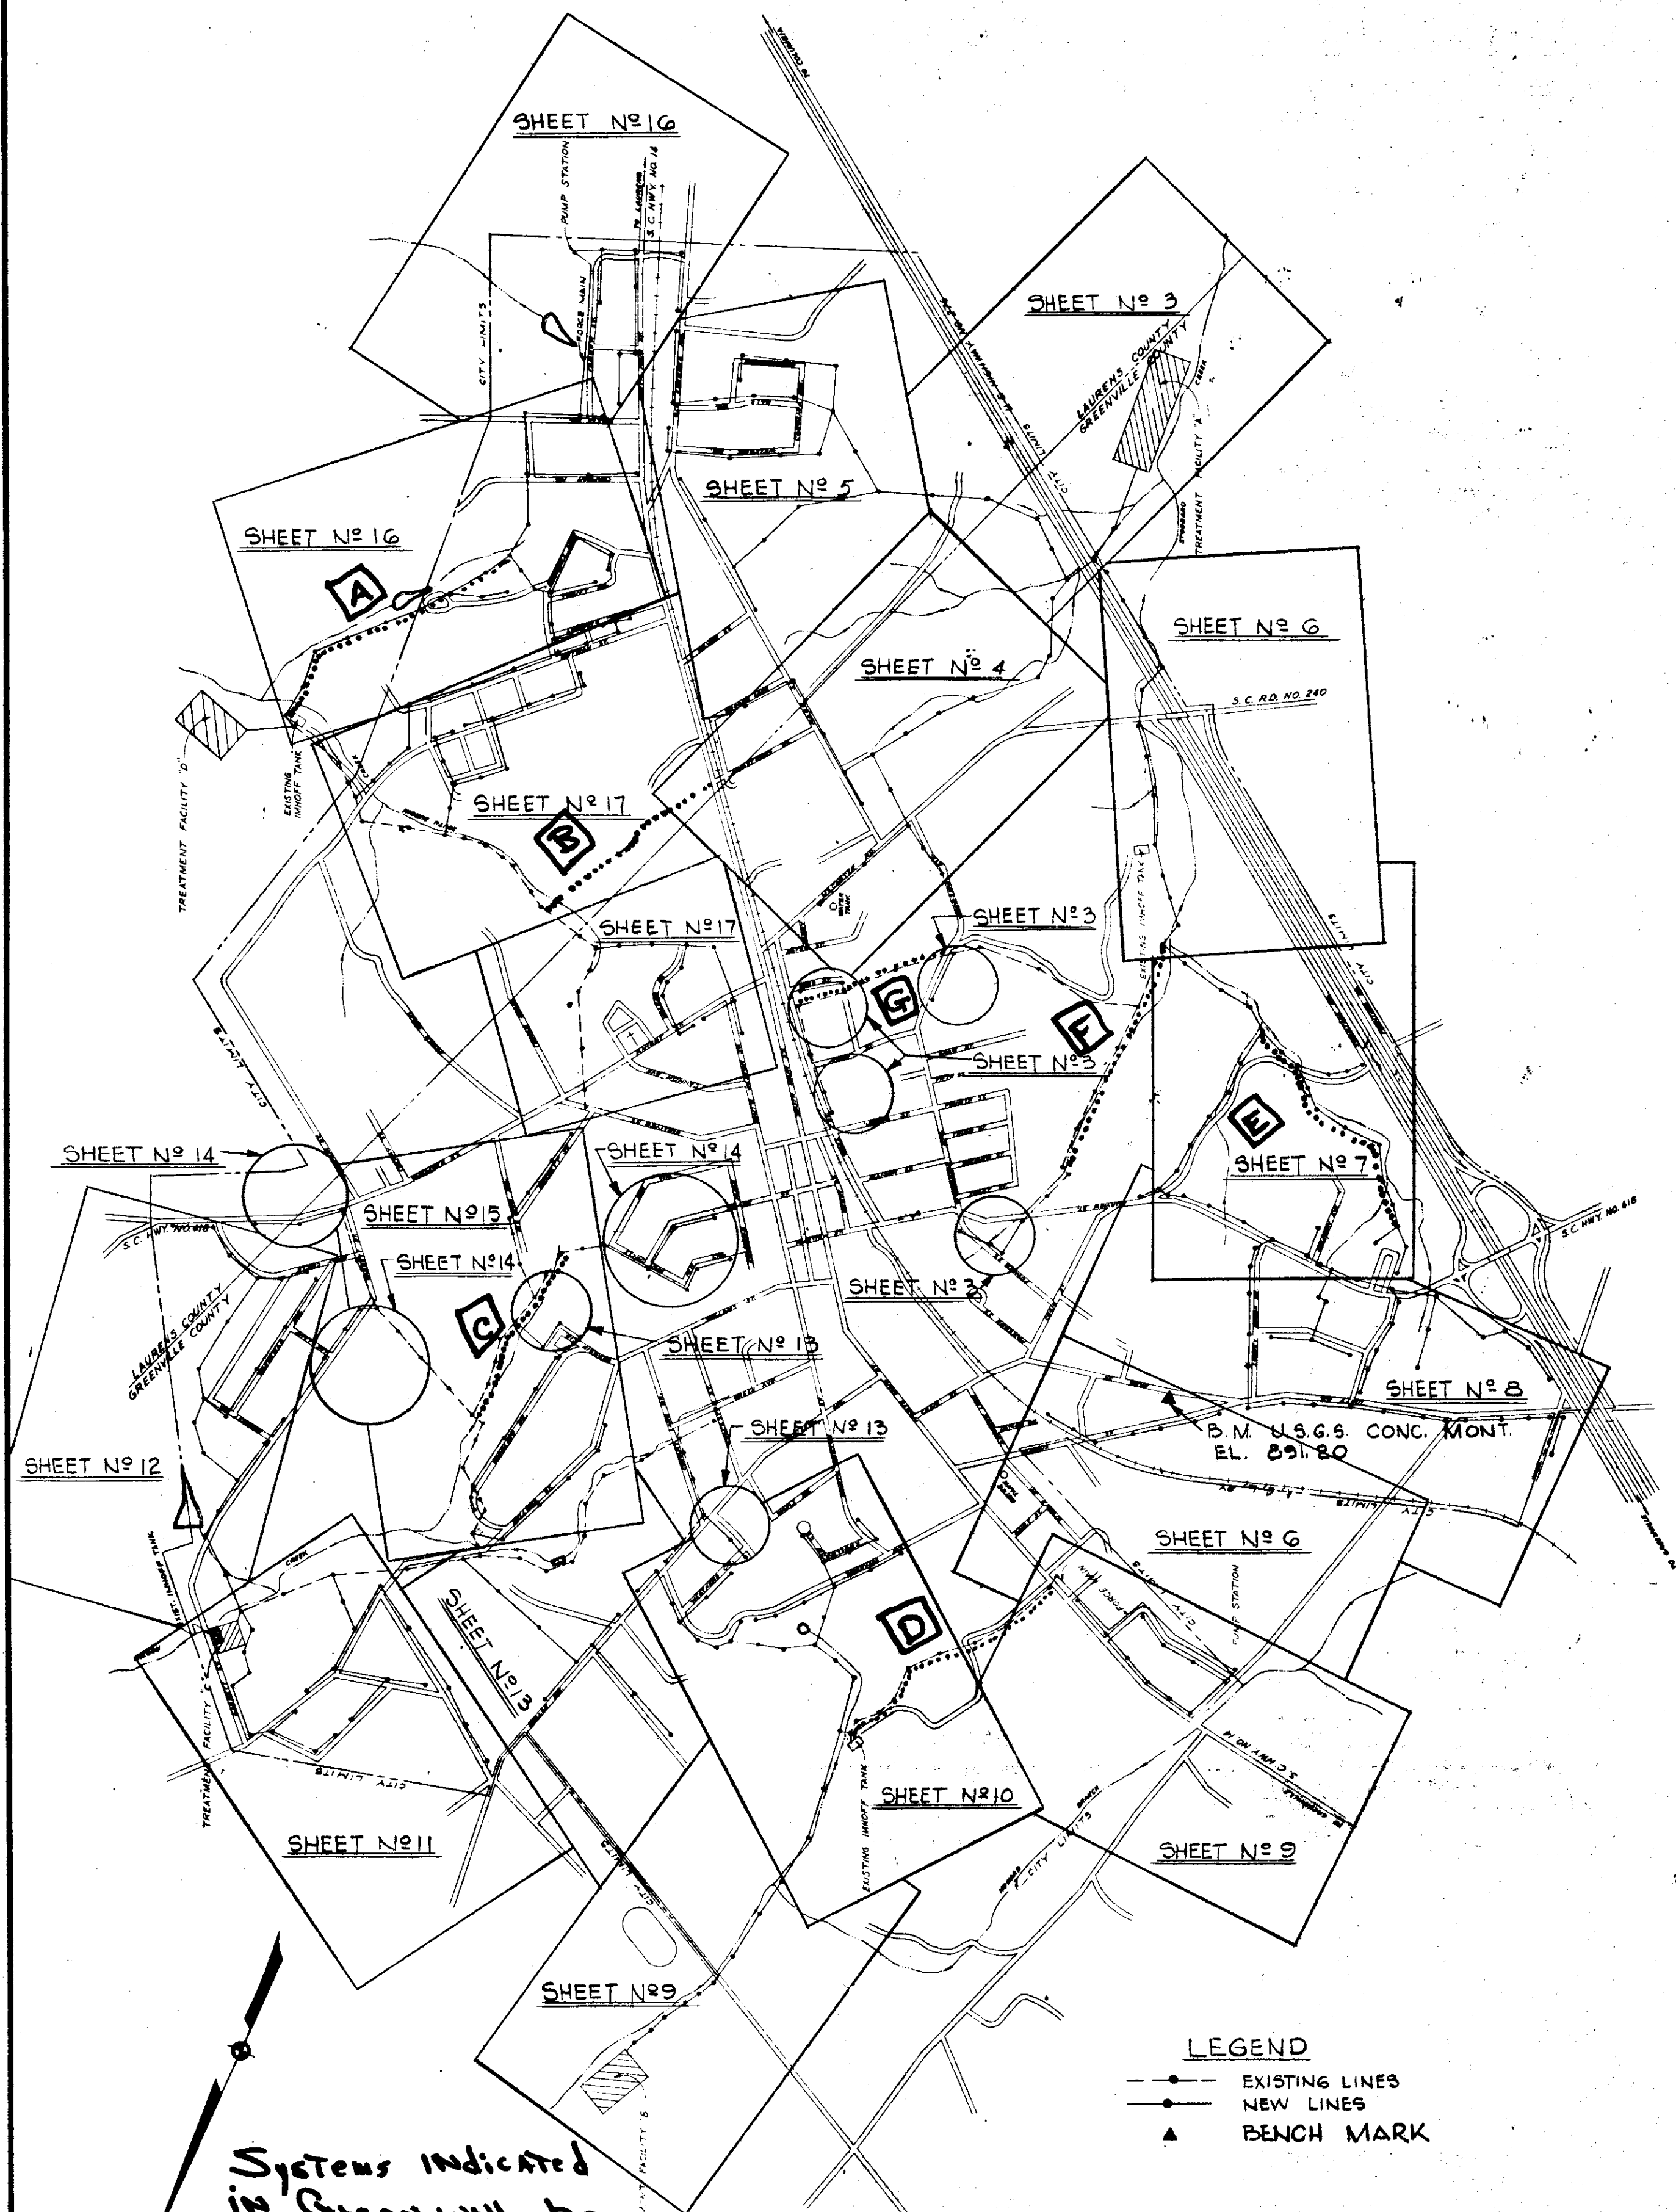

SHEET NO.	DESCRIPTION
COVER	COVER SHEET
2	INDEX, INDEX MAP
3	PLAN, SEWER LINES; A-2 TO A-5, A-4.1 TO A-4.6, AB, AC, AD, & AF
4	PLAN, SEWER LINES; A-6 TO A-16
5	PLAN, SEWER LINES; A-4.7 TO A-4.16
6	PLAN, SEWER LINES; A-3.1 TO A-3.10, A-E.1 TO A-E.7
7	PLAN, SEWER LINES; A-3.11 TO A-3.24
8	PLAN, SEWER LINES; A-3.184 TO A-3.1824
9	PLAN, SEWER LINES; B TO B-12, B-Z TO B-Z.8
10	PLAN, SEWER LINES; B-13 TO B-25
11	PLAN, SEWER LINES; C-11 TO C-19, CH-1 TO CH-8
12	PLAN, SEWER LINES; C TO C-9
13	PLAN, SEWER LINES; CF, CG, & CT
14	PLAN, SEWER LINES; CP, CM, & CN
15	PLAN, SEWER LINES; CR, CS & CO
16	PLAN, SEWER LINES; D TO D-18, DV-2 TO DV-7
17	PLAN, SEWER LINES; DU & DX
18	TREATMENT FACILITY "A" & DETAILS
19	CLARIFIER DETAILS-TREATMENT FACILITY "A"
20	AERATOR PLATFORM & JUNCTION BOX "A"
21	TREATMENT FACILITY "B" & DETAILS
22	TREATMENT FACILITY "C" & DETAILS
23	TREATMENT FACILITY "D" & DETAILS
24	DETAILS-CONCRETE OUTLET STRUCTURES
25	EJECTOR STATIONS-DETAILS
26	PUMP STATION & DETAILS
27	PLANS, EJECTOR STATIONS; BLOCKING & LEGEND
28	DETAILS-SEWER PIPE INSTALLED IN CONC. BOX CULV.
29	DETAILS-CONCRETE PIERS, FENCE & SIGN
30	DETAILS-MANHOLE & SERVICE CONNECTIONS
31	ELECTRICAL PLANS & DETAILS

SHEET NO.	DESCRIPTION
P-1	PROFILES-A-1
P-2	PROFILES-A-2
P-3	PROFILES-A-3
P-4	PROFILES-A-4
P-5	PROFILES-A-5
P-6	PROFILES-A-6
P-7	PROFILES-A-7
P-8	PROFILES-A-8
P-9	PROFILES-B-1
P-10	PROFILES-B-2
P-11	PROFILES-B-3
P-12	PROFILES-B-4
P-13	PROFILES-C-1
P-14	PROFILES-C-2
P-15	PROFILES-C-3
P-16	PROFILES-C-4
P-17	PROFILES-C-5
P-18	PROFILES-C-6
P-19	PROFILES-D-1
P-20	PROFILES-D-2
P-21	PROFILES-D-3
P-22	PROFILES-D-4

### REVISIONS

P-1	A-3A - A-4.73
P-2	B-10 - B-10.3
P-3	A-3.5 - A-3.6, C-1 - C-4
P-4	A-3.25 - A-3.28, A-3.23 - A-3.232, B-24 - B-24.1A, AD - AD.B
P-5	B-23 - B-24
P-6	A-3.A - A-3.7

**LEGEND**  
 - - - - - EXISTING LINES  
 ———— NEW LINES  
 ▲ BENCH MARK

*Systems indicated in Green will be maintained by Greenville County Sewer Authority.  
 Carl C. Sanford, Engineer*

BOOK 4 V PAGE 142

<b>DAVIS AND FLOYD ENGINEERS, INC.</b> CONSULTING ENGINEERS GREENWOOD, S. C.      ATLANTA, GA.	OWNER <b>TOWN OF FOUNTAIN INN</b> FOUNTAIN INN, S. C.	TITLE <b>INDEX, INDEX MAP</b>	DESIGNED: _____ DRAWN: M. N. H. CHECKED: P. R. F. APPROVED: P. R. F.      DATE _____	SCALE: AS SHOWN DATE: MAY 1966	CONTRACT NO. WPC-5C-131 SH. 2 OF 5
--	---	----------------------------------	---	--------------------------------------	--