



FED. ROAD DIST. NO.	STATE	FEDERAL PROJ. NO.	FISCAL YEAR	SHEET NO.	TOTAL SHEETS

PLAN	DATE	BY
SURVEYED, CALCULATED, CHECKED, ALIGNED, PLANNED, RT. OF WAY CHECKED.		
NOTE BOOK NO.		

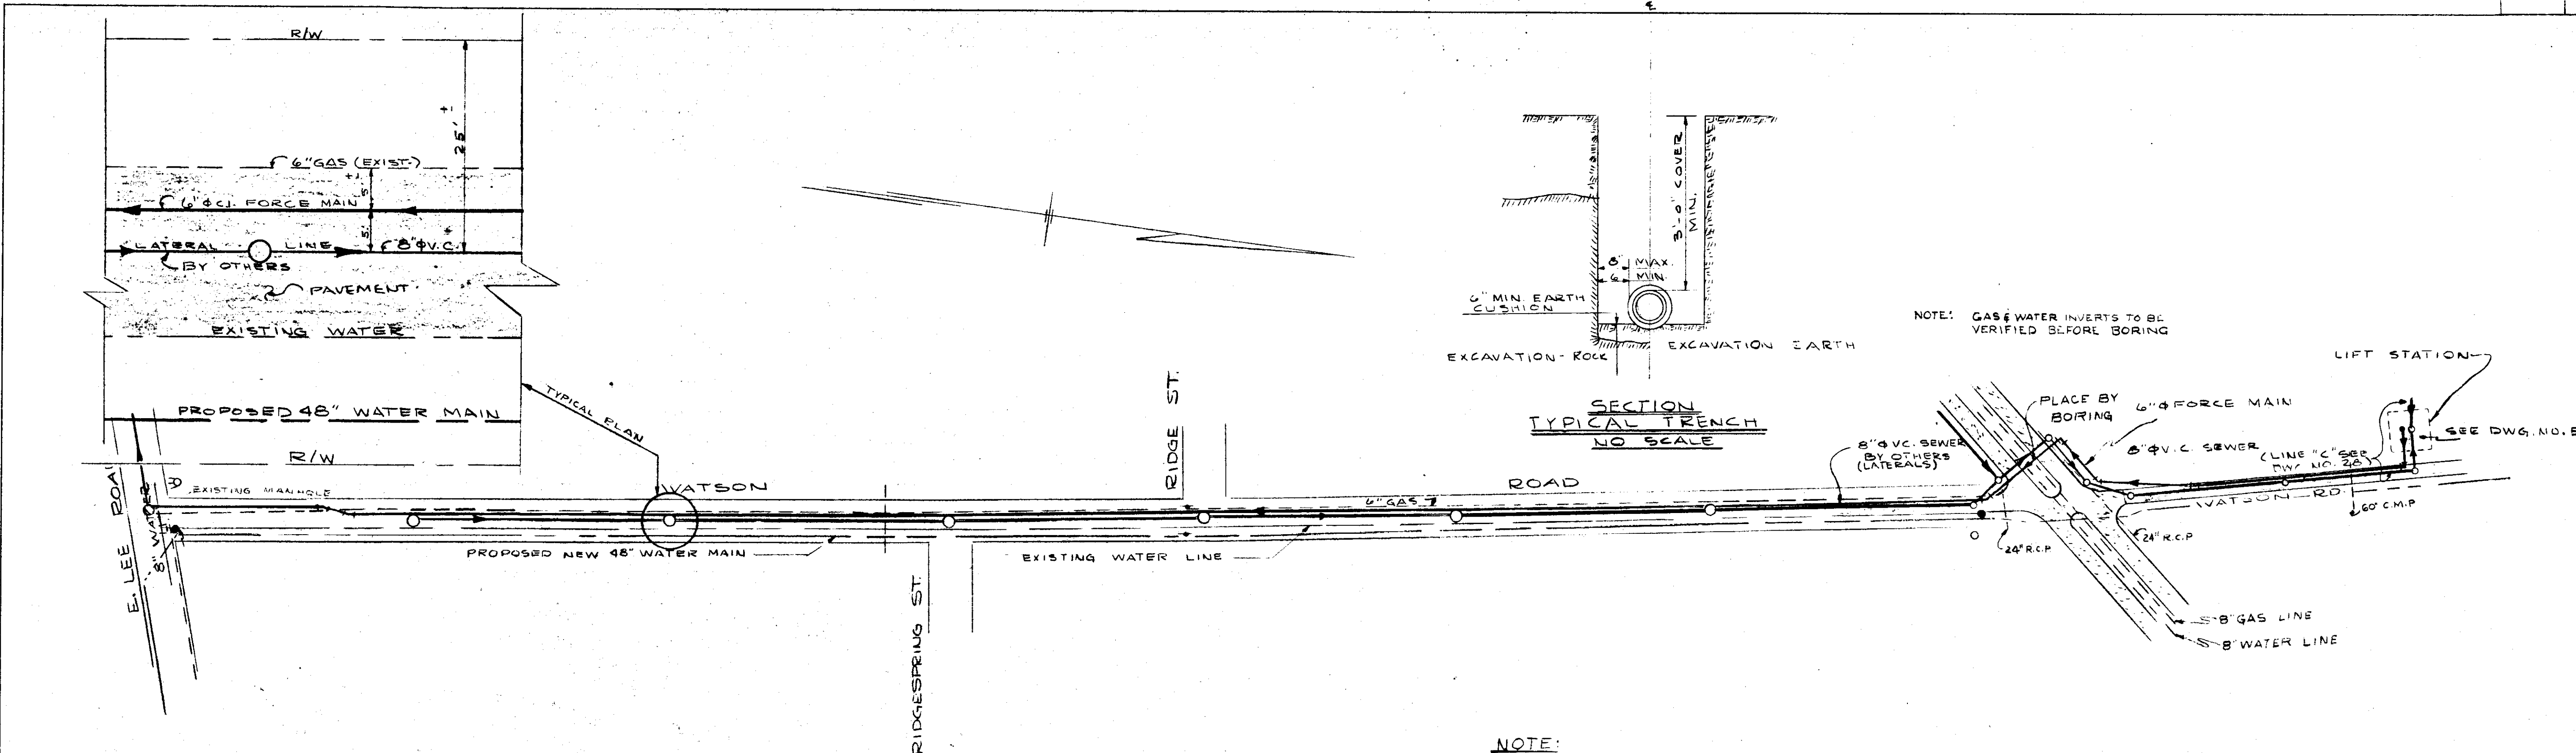

PROFILE	DATE	BY
SURVEYED, PLOTTED, GRADES CHECKED, W. M. NUMBER, STRUCTURE, NOTATION, CH. NO.		
NOTE BOOK NO.		

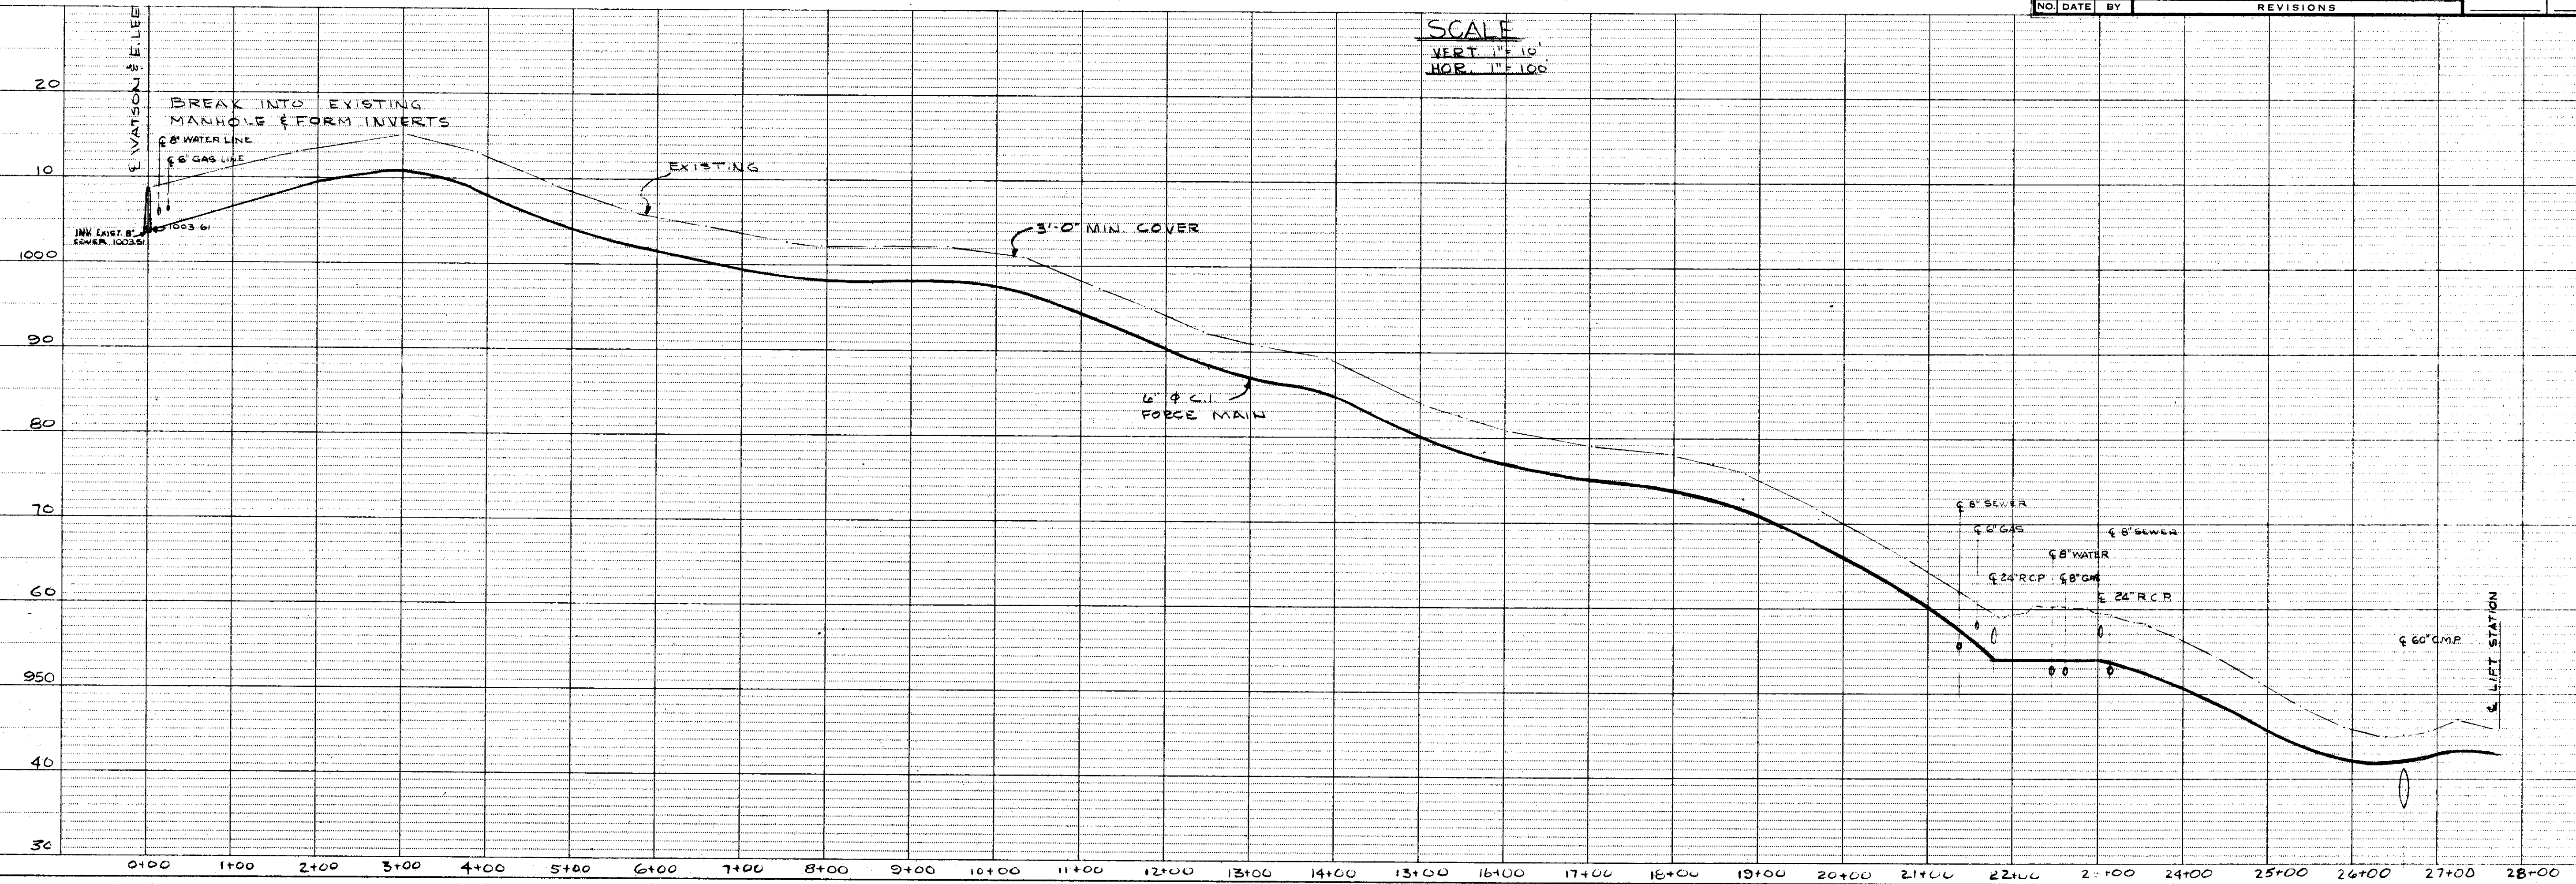

WADE HAMPTON WATER AND SEWER DISTRICT GREENVILLE COUNTY, S. C.	
PLAN AND PROFILE FORCE MAIN	
PIEDMONT ENGINEERING SERVICE GREENVILLE, S. C.	
DRAWN BY	CHECKED BY
DATE	DATE
JULY 1963	
DWG. NO. 8	