


FED. ROAD DIST. No.	STATE	FEDERAL PROJ. NO.	FISCAL YEAR	SHEET No.	TOTAL SHEETS

PLAN	DATE
SUBMITTED	
PLOTTED	
ALIGNED CHECKED	
NO. OF WAY CHECKED	
NO.	

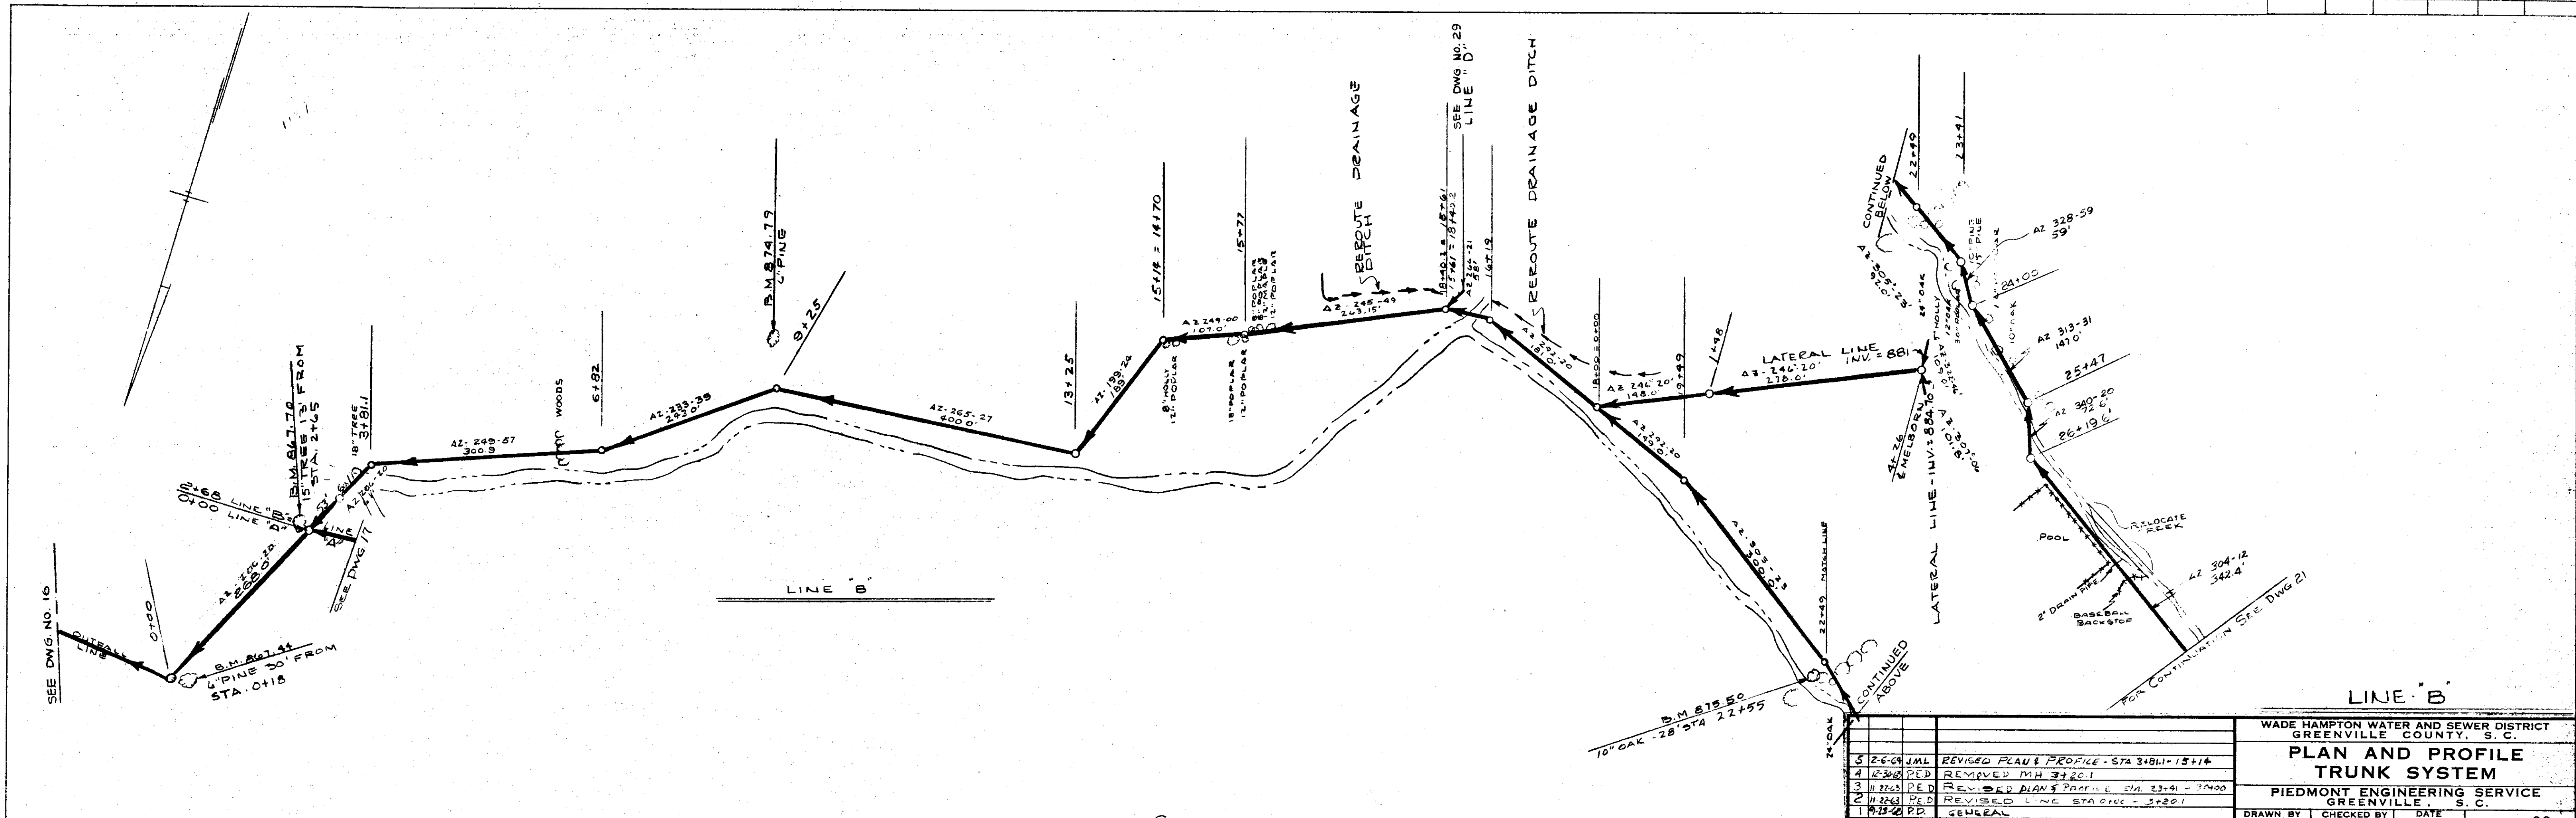

NO.	DATE	BY	REVISIONS
5	2-6-69	JML	REVISED PLAN & PROFILE - STA 3+81.1 - 15+14
4	2-24-68	CEB	REMOVED DIA. 36"
3	11-22-67	RED	REVISED PLAN & PROFILE STA 23+41 - 24+00
2	11-22-67	RED	REVISED LINE STATIONING 3+201
1	10-25-67	PER	GENERAL


WADE HAMPTON WATER AND SEWER DISTRICT
GREENVILLE COUNTY, S. C.

PLAN AND PROFILE TRUNK SYSTEM

PIEDMONT ENGINEERING SERVICE
GREENVILLE, S. C.

DRAWN BY: _____ CHECKED BY: _____ DATE: JULY 1963 DWG. No. 20

PROFILE	DATE
SUBMITTED	
PLOTTED	
CHECKED	
NO. OF WAY CHECKED	
NO.	

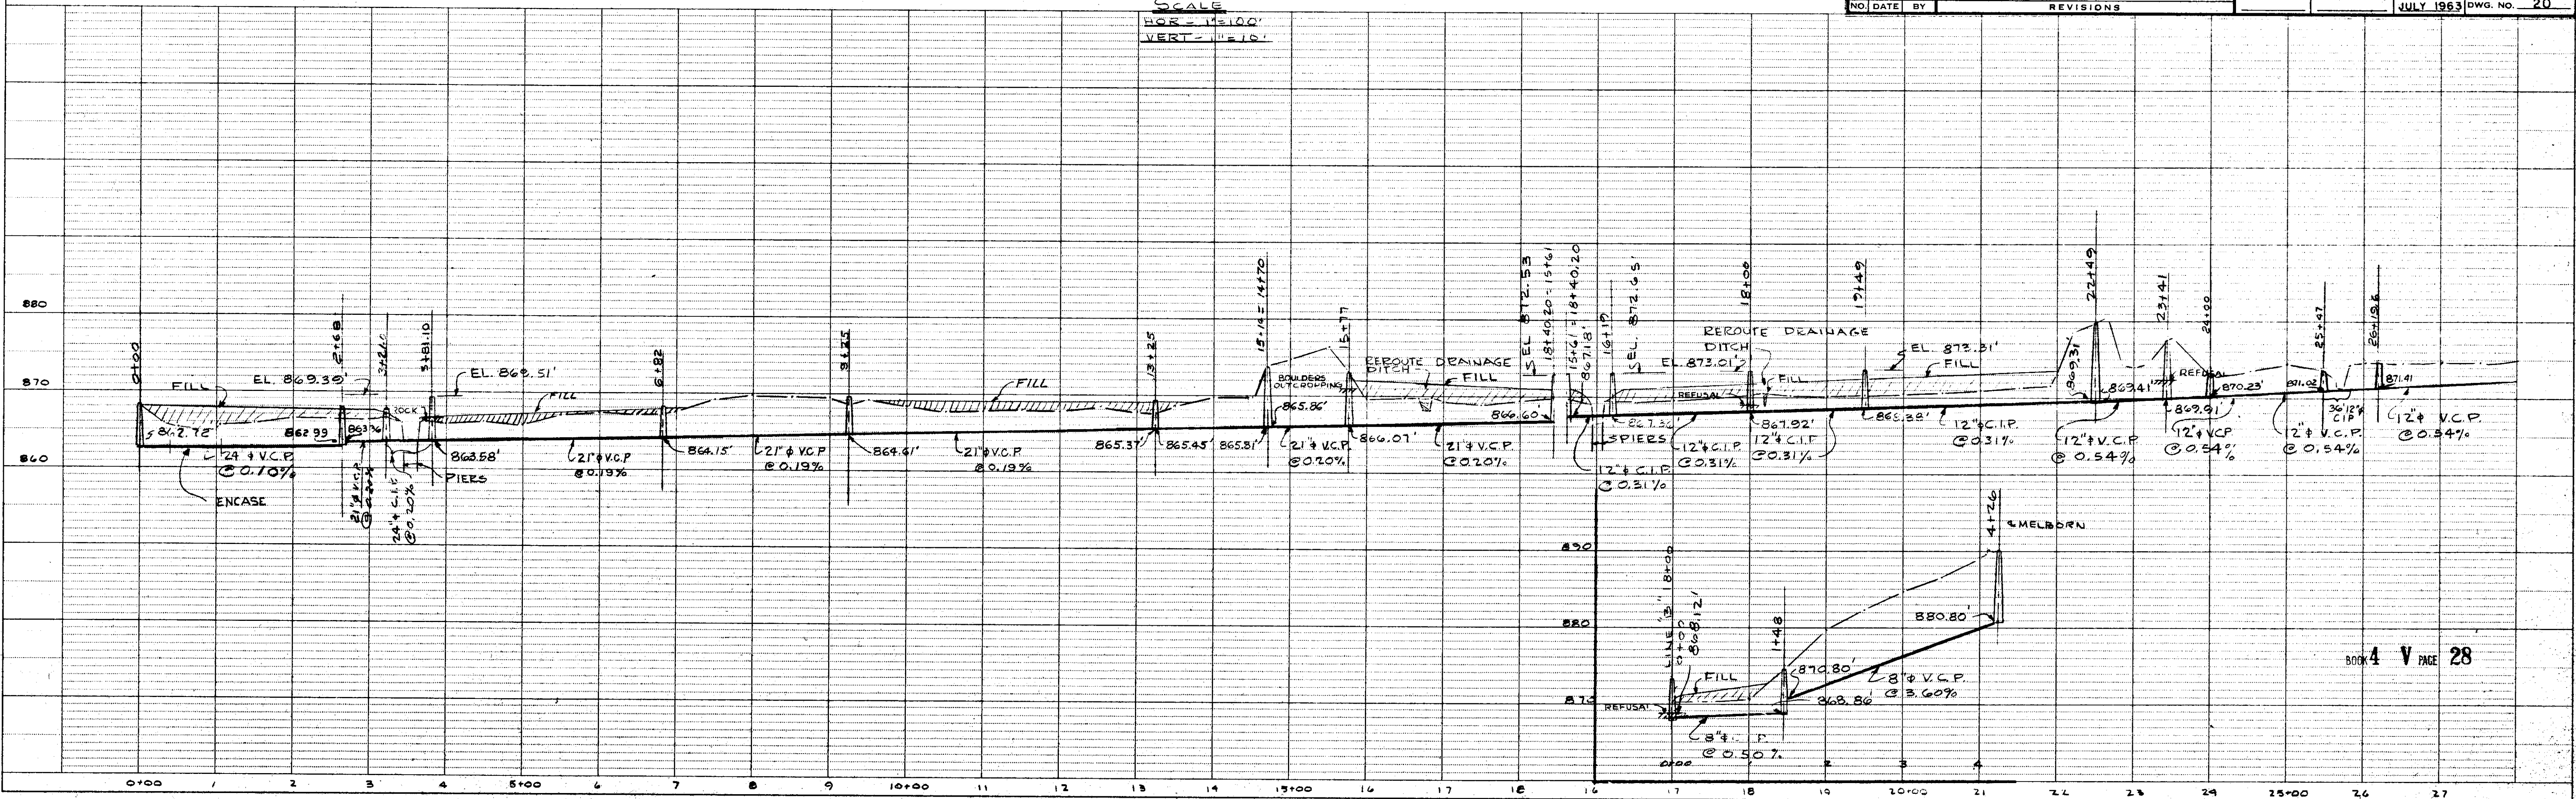

SINGLE PLAN AND PROFILE - DOTTED
H. A. ROGERS CO. - MINNEAPOLIS - ST. PAUL - DULUTH