



FED. ROAD DIST. NO.	STATE	FEDERAL PROJ. NO.	FISCAL YEAR	SHEET NO.	TOTAL SHEETS
---------------------	-------	-------------------	-------------	-----------	--------------

PLAN	BY	DATE
SURVEYED		
ALIGNMENT CHECKED		
NOTE BOOK		
RT. OF WAY CHECKED		
NO.		

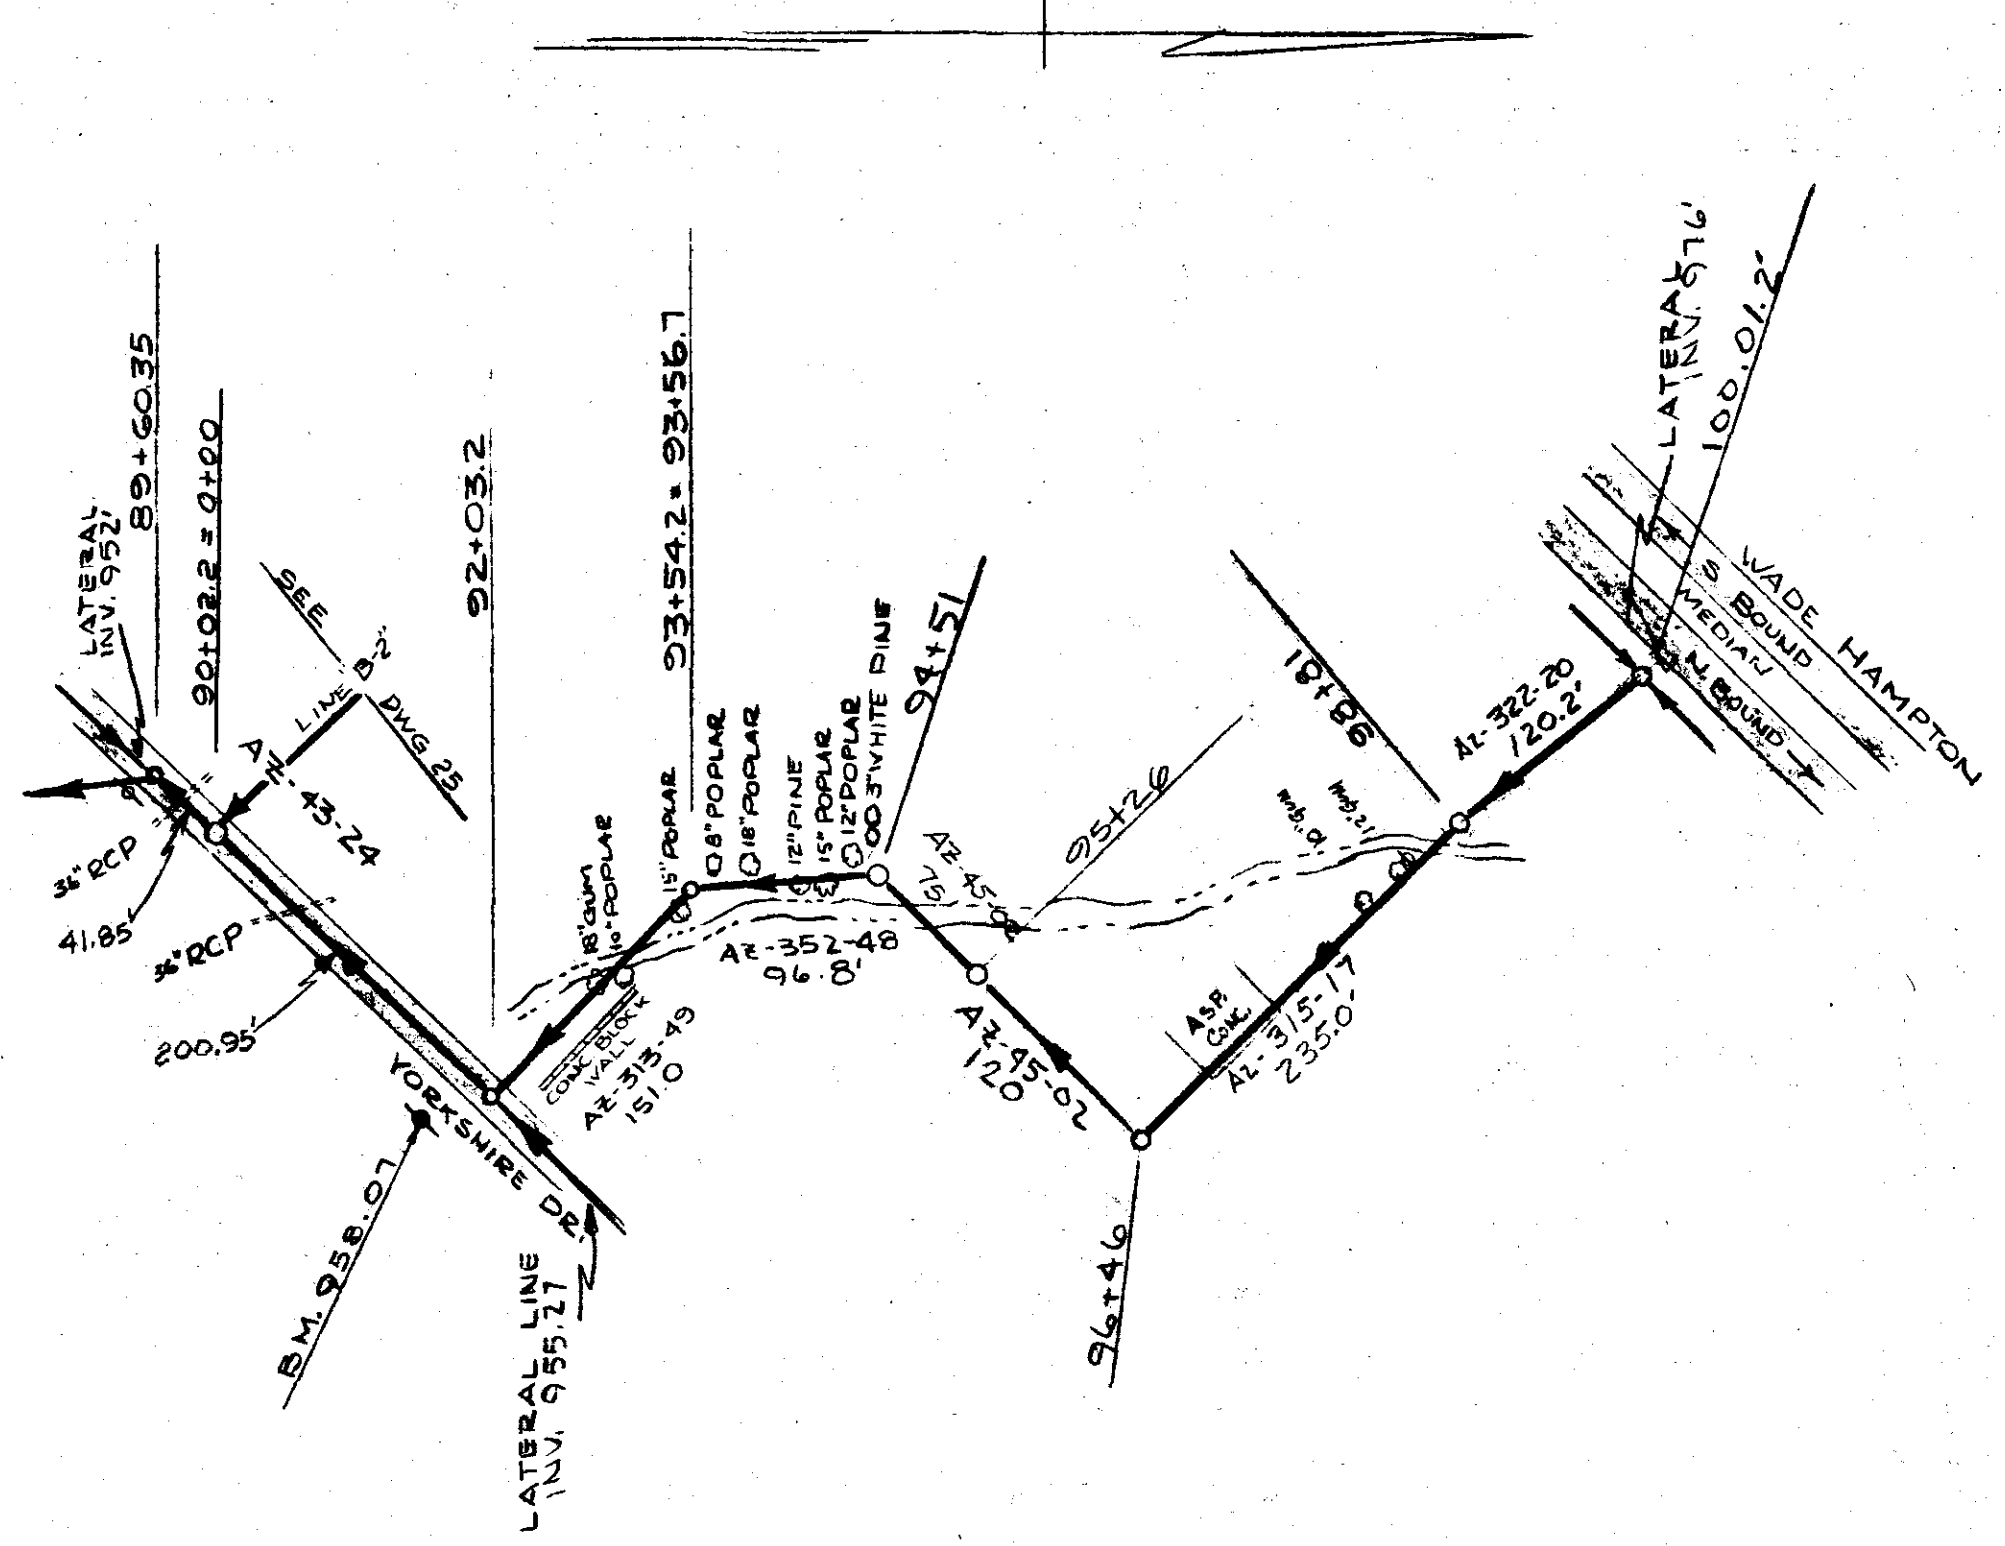

PROFILE	BY	DATE
SURVEYED		
GRADES CHECKED		
NOTE BOOK		
STRUCTURE NOTATIONS CHKD		
NO.		

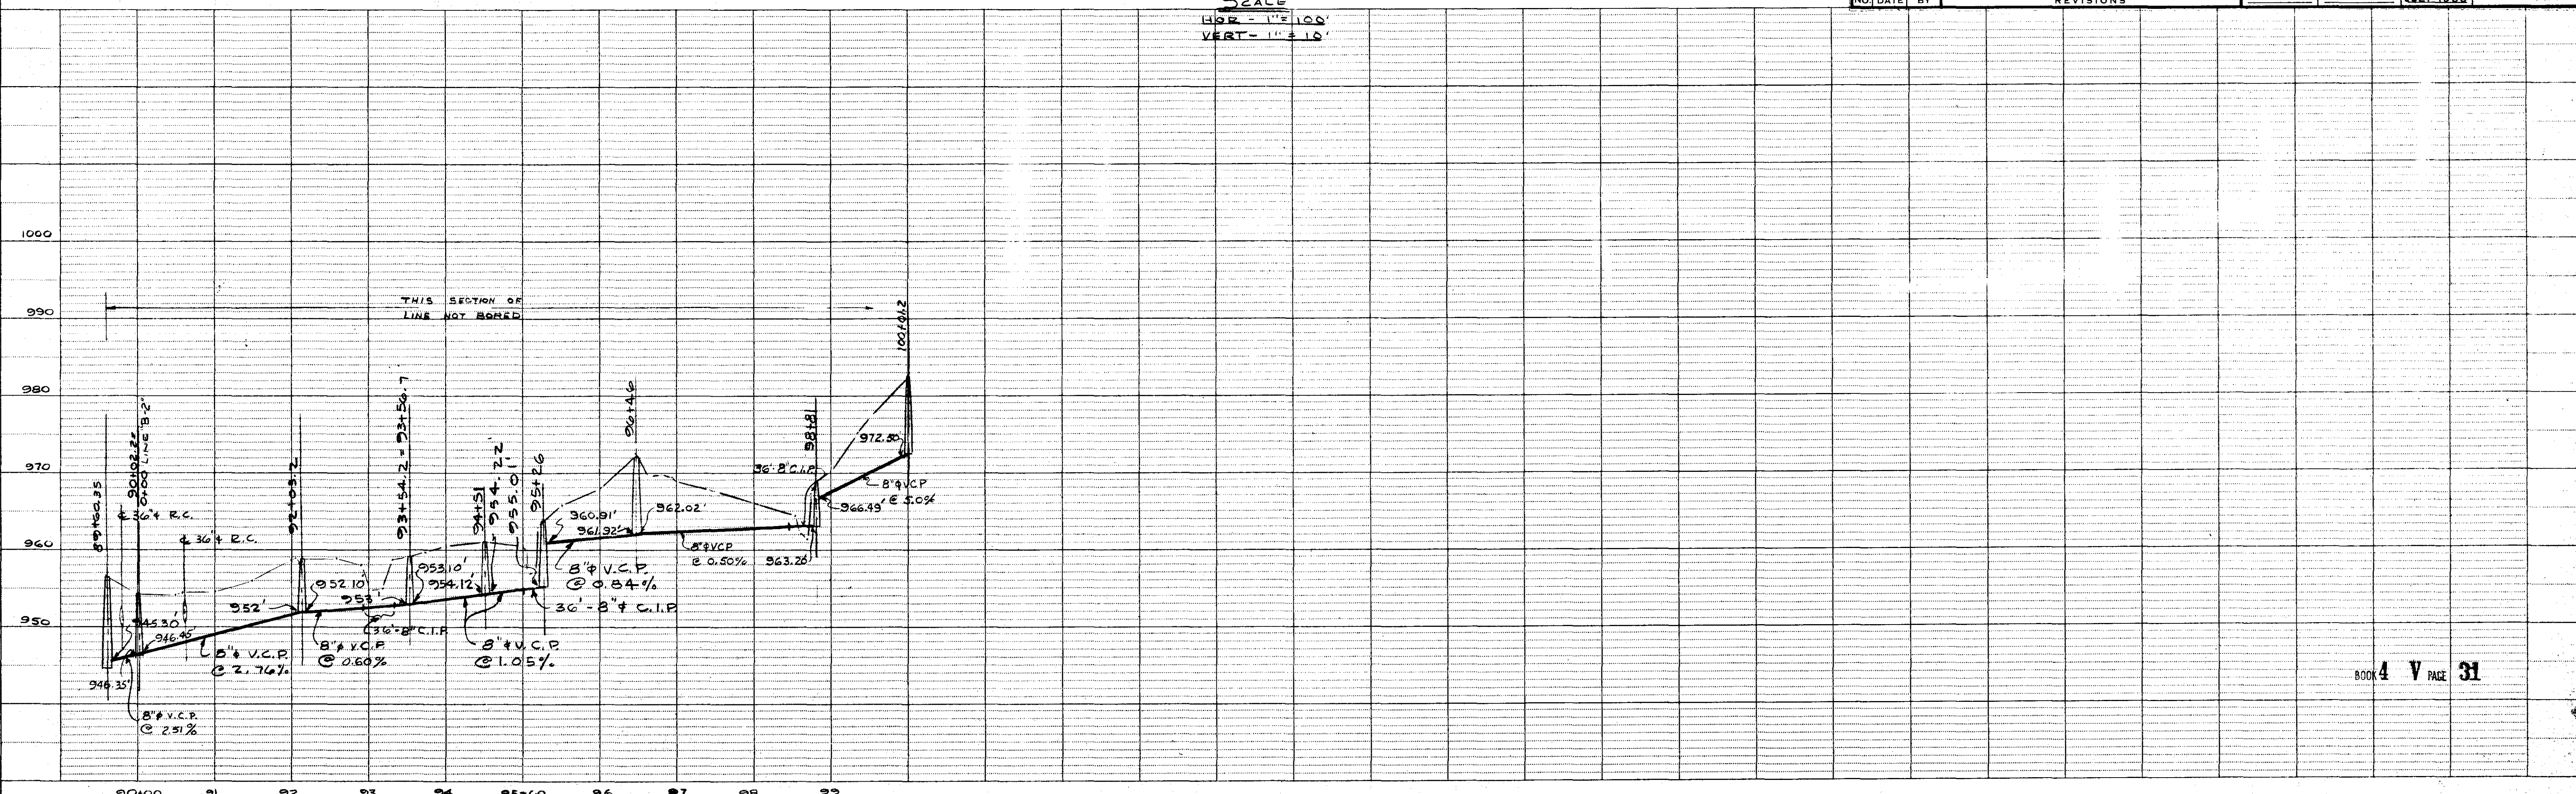

LINE 'B'

WADE HAMPTON WATER AND SEWER DISTRICT GREENVILLE COUNTY, S. C.	
PLAN AND PROFILE TRUNK SYSTEM	
PIEDMONT ENGINEERING SERVICE GREENVILLE, S. C.	
NO. DATE BY	REVISIONS
3 5-28-64 J.M.L.	REVISED PLAN & PROFILE STA. 95+26-100+02
2 1-7-64 P.E.D.	REVISED PLAN & PROFILE
1 9-23-63 P.D.	GENERAL
DRAWN BY	CHECKED BY DATE
	JULY 1963 DWG. NO. 23

BOOK 4 V PAGE 31