


FED. ROAD DIST. No.	STATE	FEDERAL PROJ. NO.	FISCAL YEAR	SHEET No.	TOTAL SHEETS
---------------------	-------	-------------------	-------------	-----------	--------------


PLAN	NO. 1	DATE
NO.		

PROFILE	NO. 1	DATE
NO.		

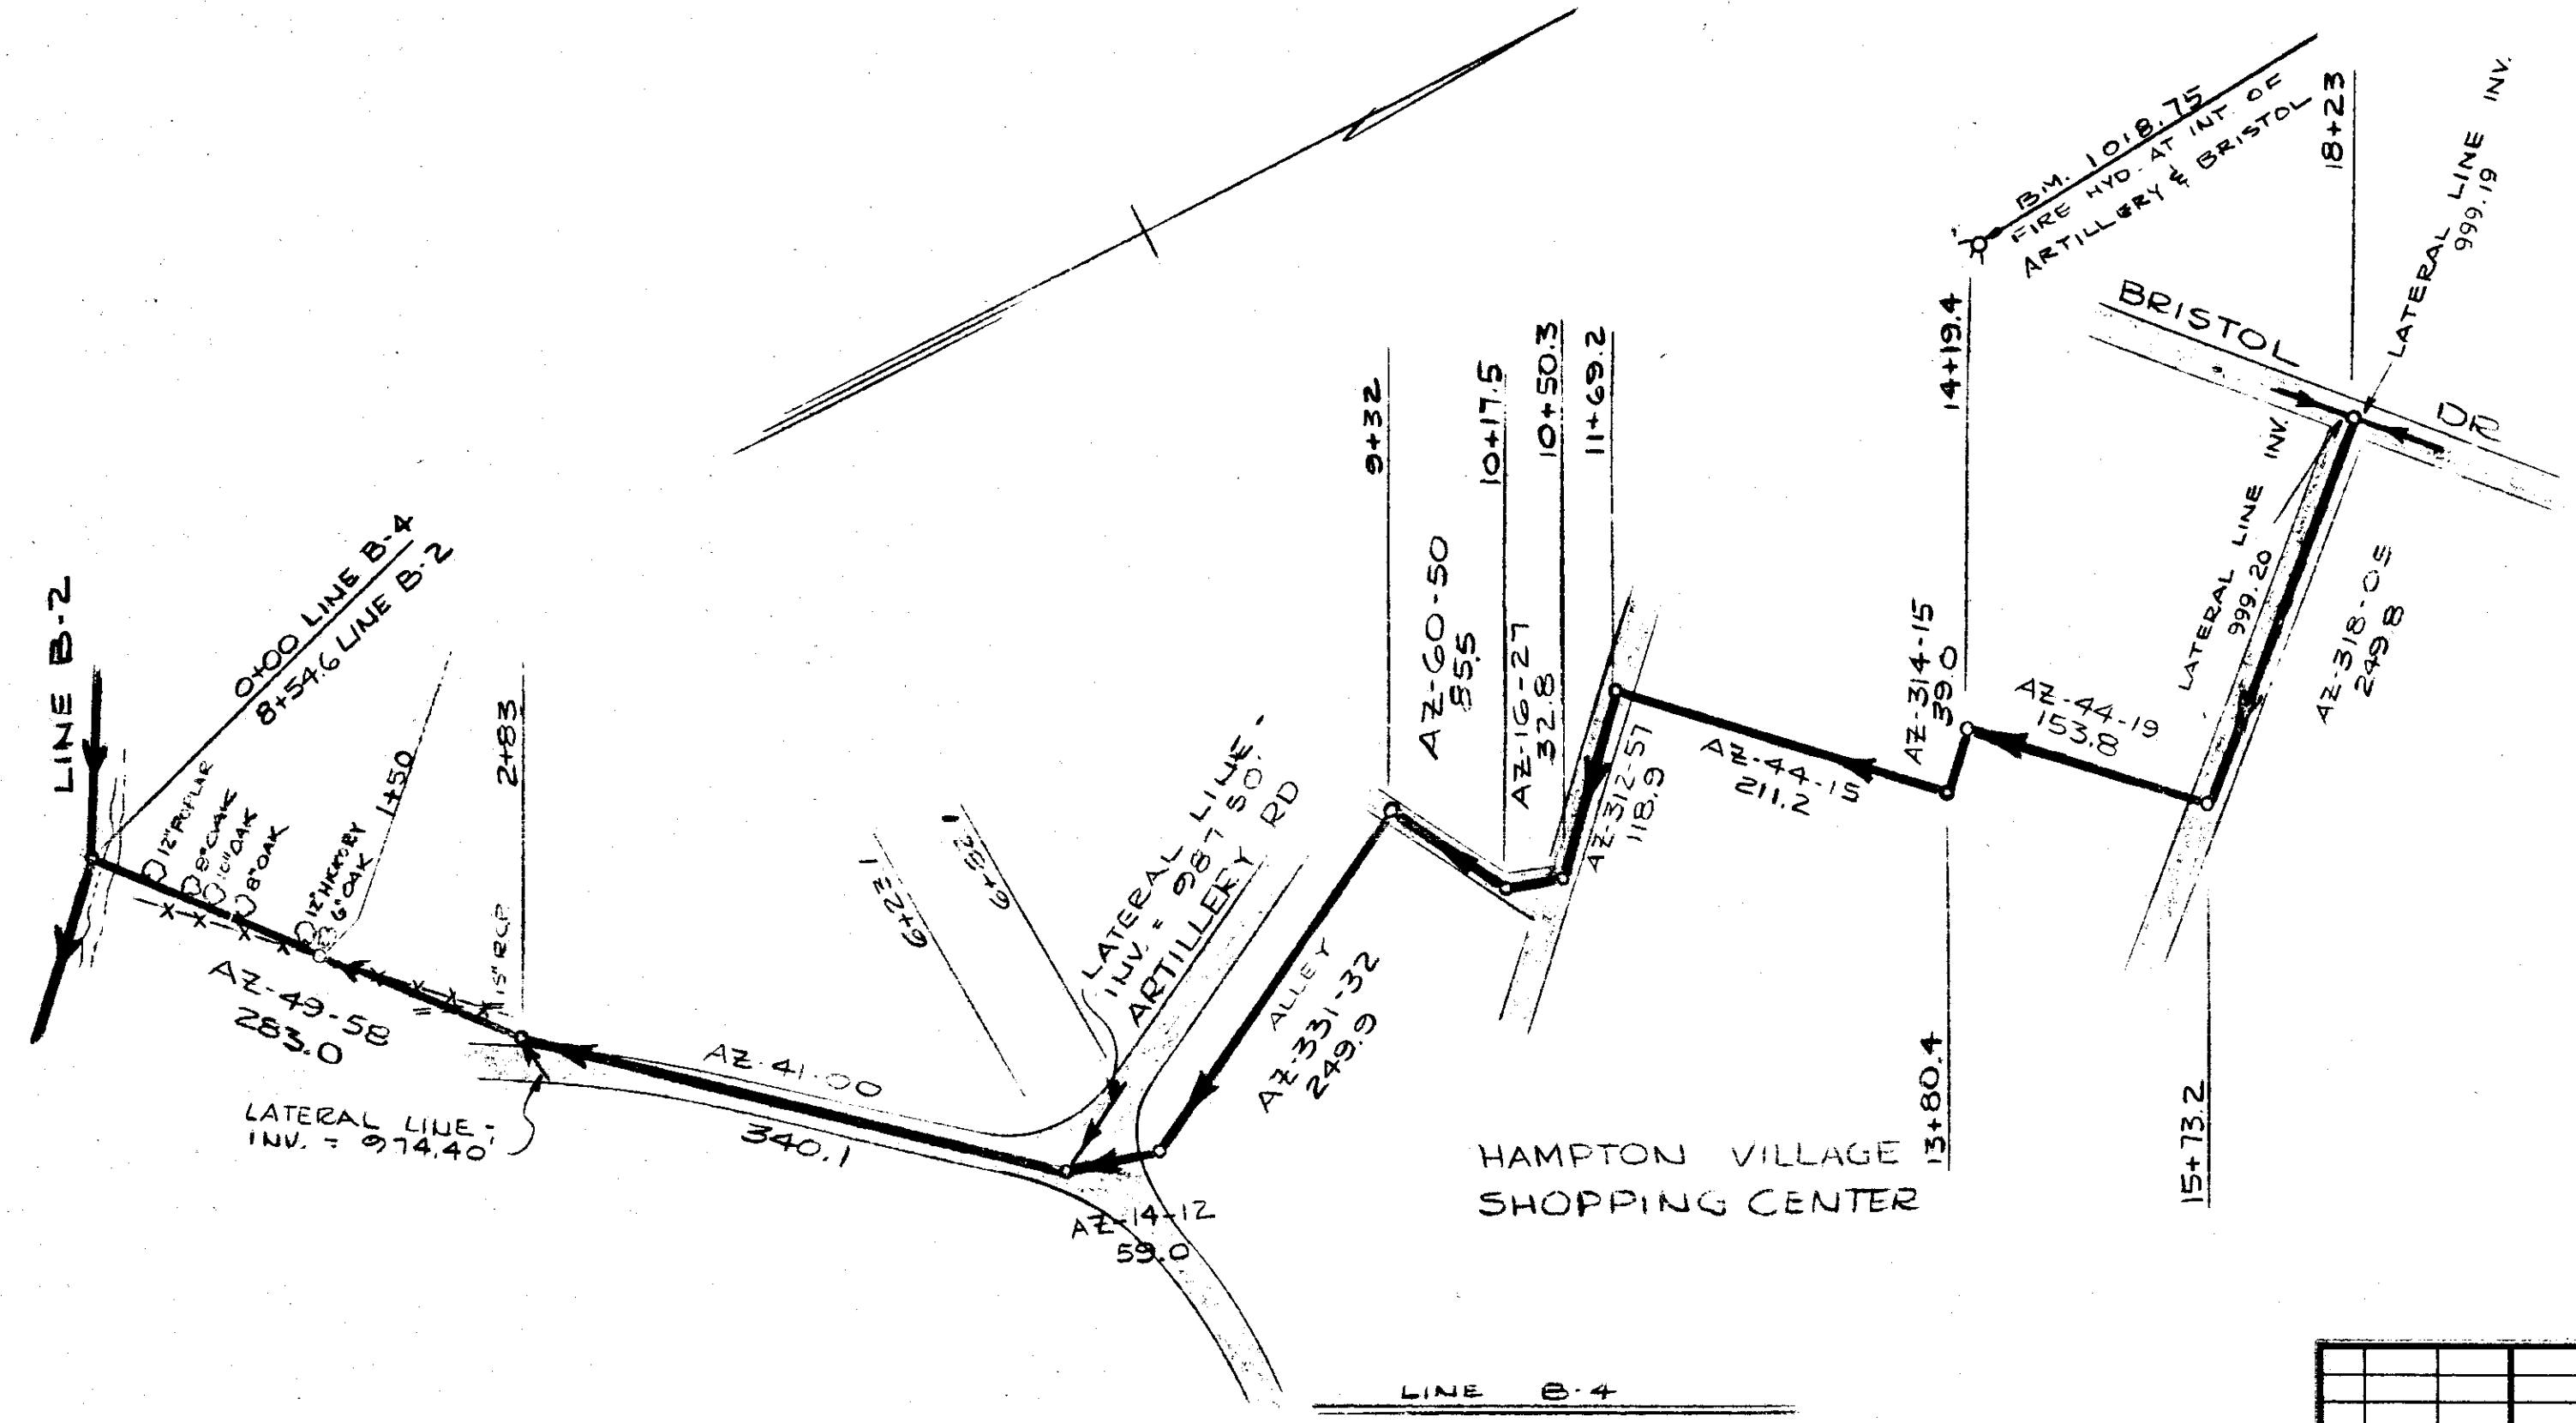

NO. DATE		BY	GENERAL	REVISIONS

LINE B-4  
 WADE HAMPTON WATER AND SEWER DISTRICT  
 GREENVILLE COUNTY, S. C.  
**PLAN AND PROFILE**  
**TRUNK SYSTEM**  
 PIEDMONT ENGINEERING SERVICE  
 GREENVILLE, S. C.  
 DRAWN BY: \_\_\_\_\_ CHECKED BY: \_\_\_\_\_ DATE: JULY 1953 DWG. NO. 26

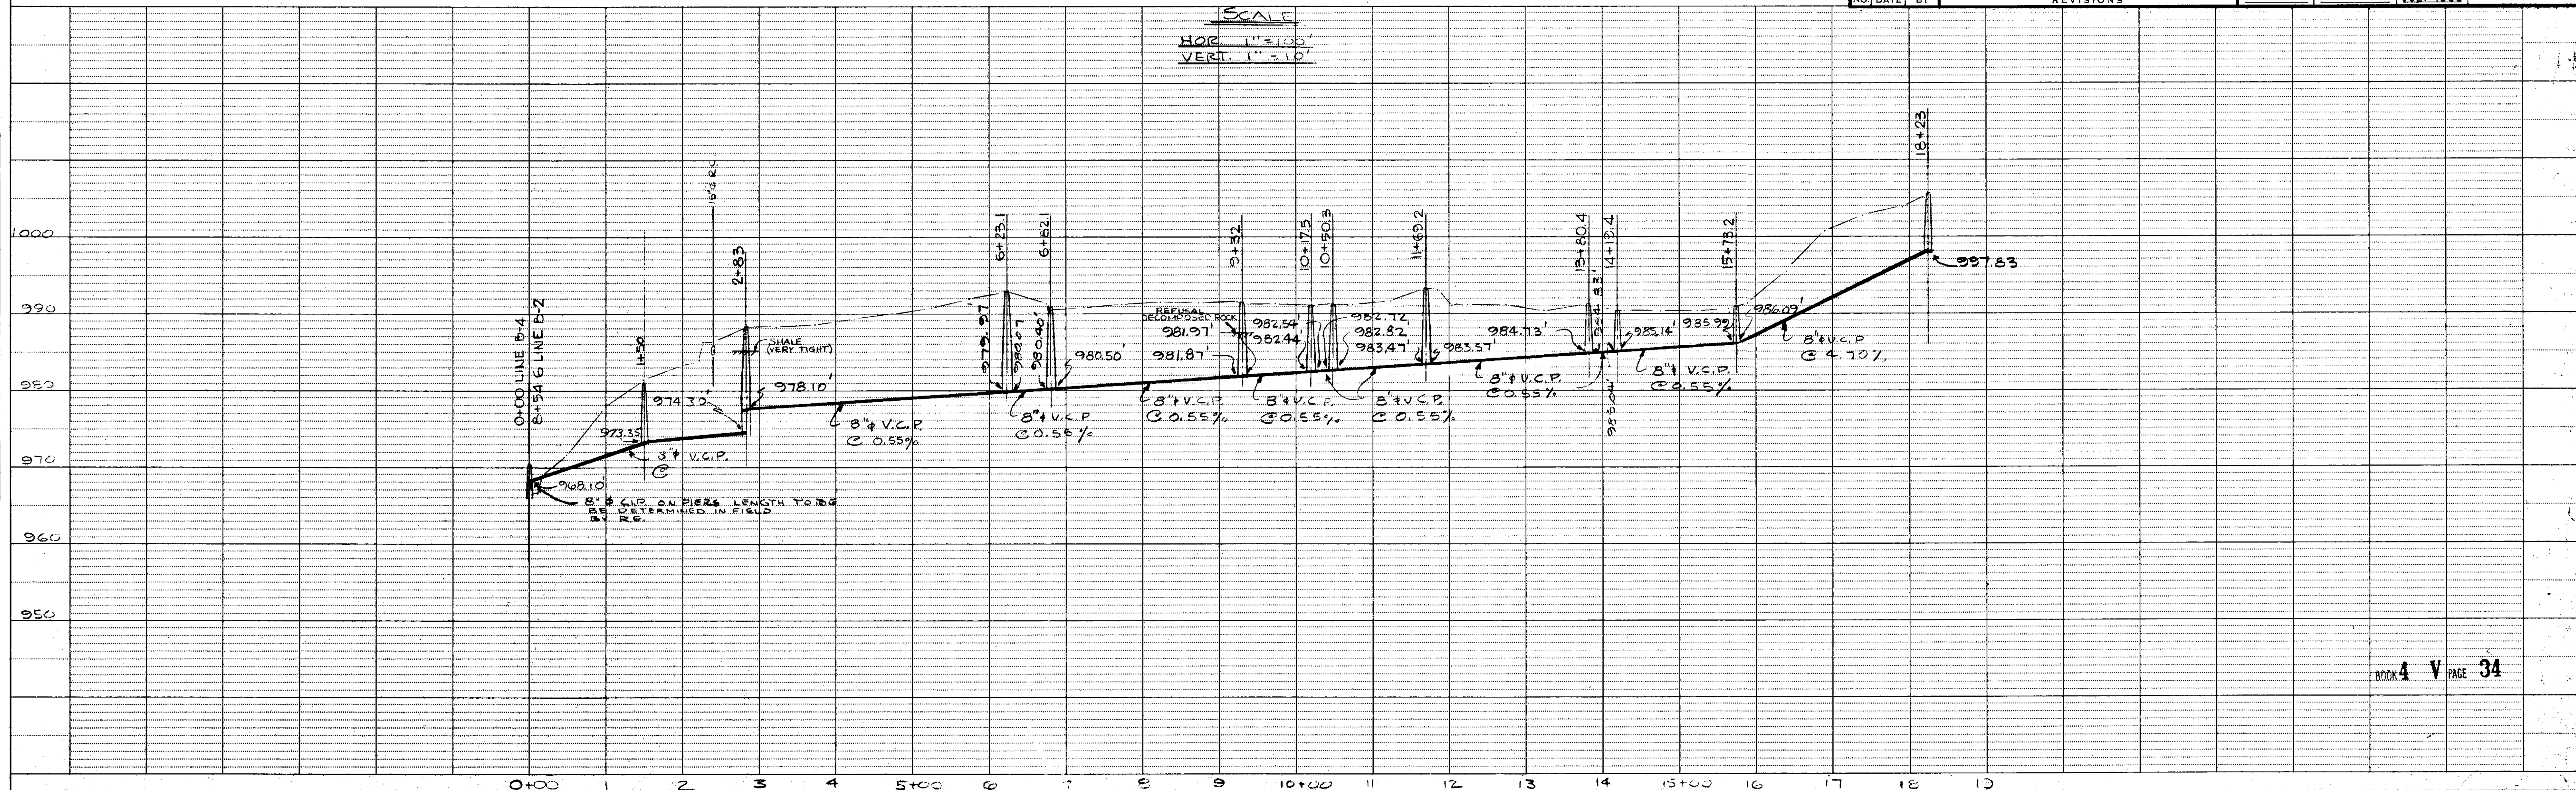

SINGLE PLAN AND PROFILE - DOTTED  
 H. A. ROGERS CO. - MINNEAPOLIS - ST. PAUL - DULUTH