



FED. ROAD DIST. No.	STATE	FEDERAL PROJ. NO.	FISCAL YEAR	SHEET No.	TOTAL SHEETS
---------------------	-------	-------------------	-------------	-----------	--------------

DATE	BY
SURVEYED, GRADES CHECKED, STRUCTURE NOTING CHKD.	
NOTE BOOK NO. _____	
NO. _____	

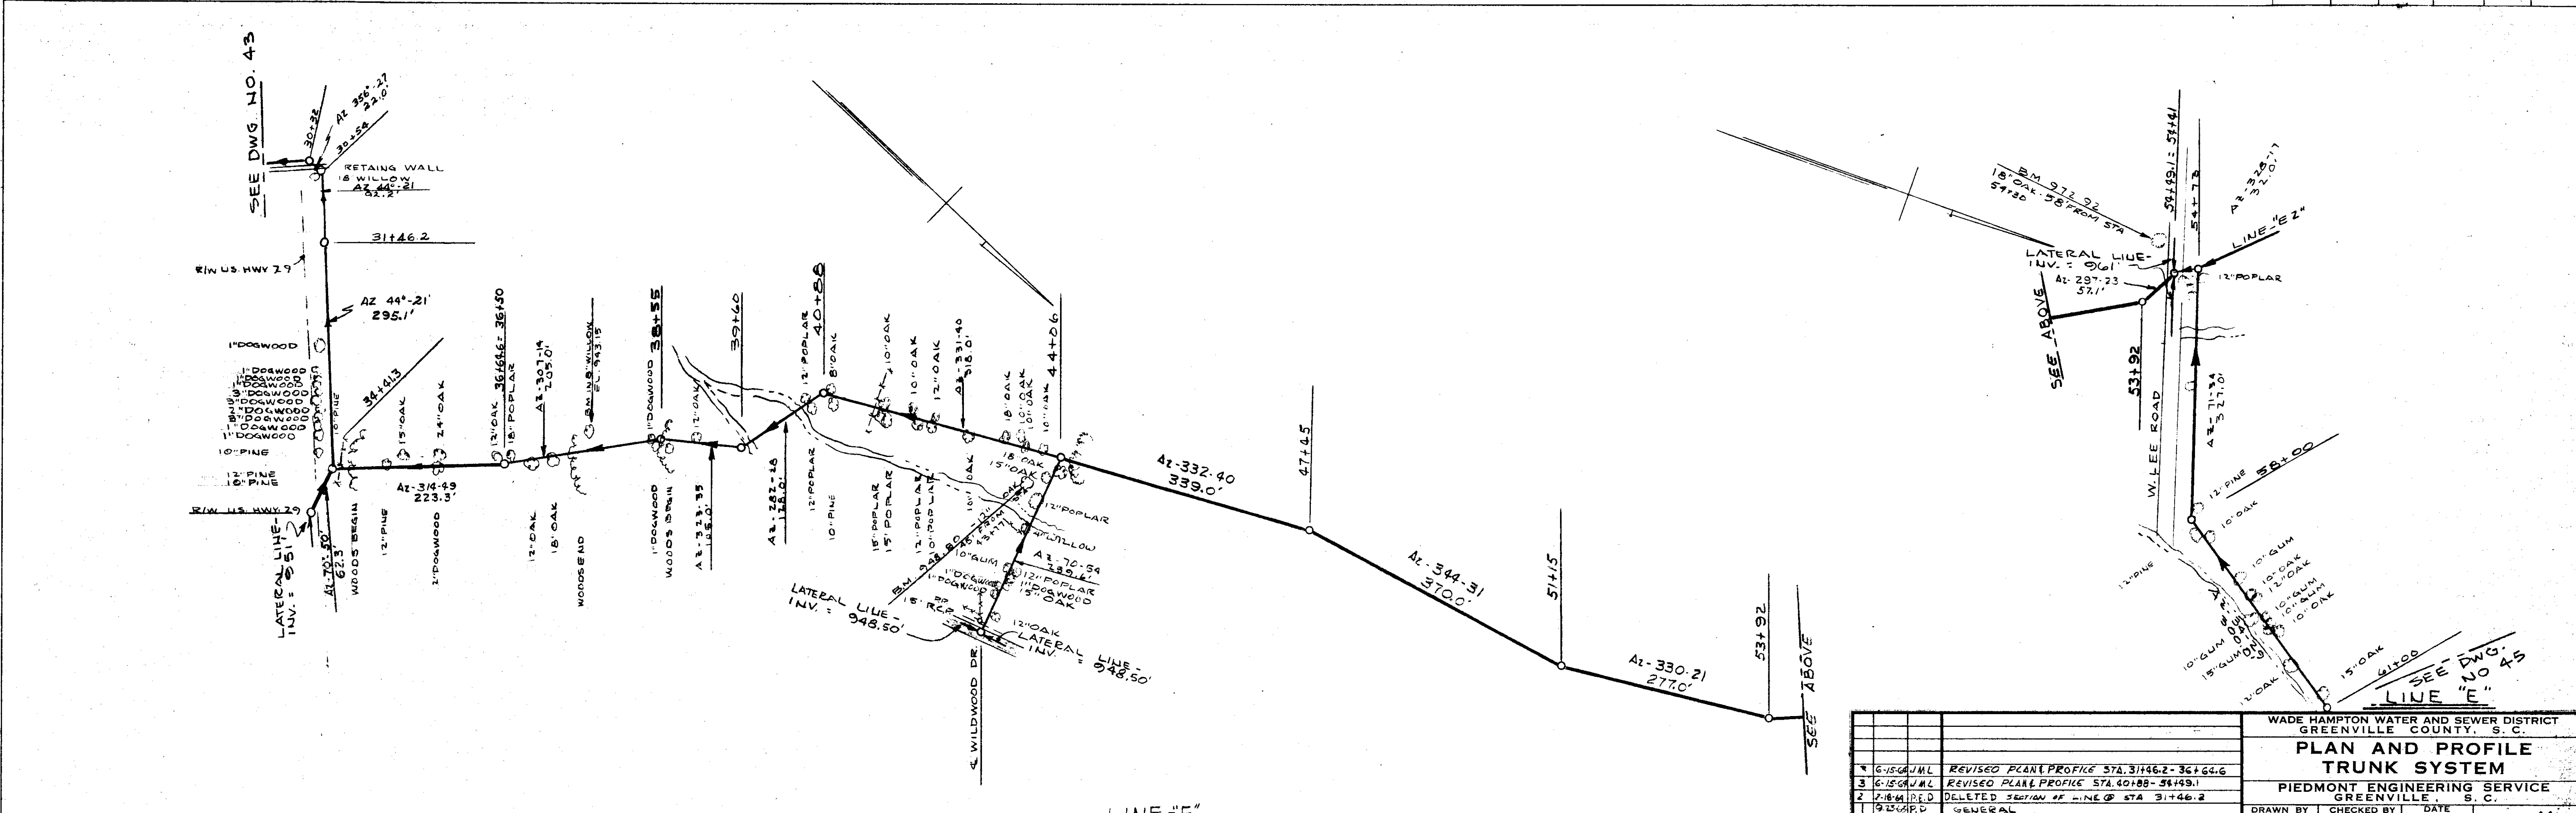

WADE HAMPTON WATER AND SEWER DISTRICT GREENVILLE COUNTY, S. C.			
PLAN AND PROFILE TRUNK SYSTEM			
PIEDMONT ENGINEERING SERVICE GREENVILLE, S. C.			
NO.	DATE	BY	REVISIONS
1			GENERAL
2			DELETED SECTION OF LINE @ STA 31+46.2
3			REVISED PLAN PROFILE STA. 31+46.2-36+64.6
4			REVISED PLAN PROFILE STA. 40+88-54+49.1
5			REVISED PLAN PROFILE STA. 54+49.1-58+00

DATE	BY
SURVEYED, GRADES CHECKED, STRUCTURE NOTING CHKD.	
NOTE BOOK NO. _____	
NO. _____	

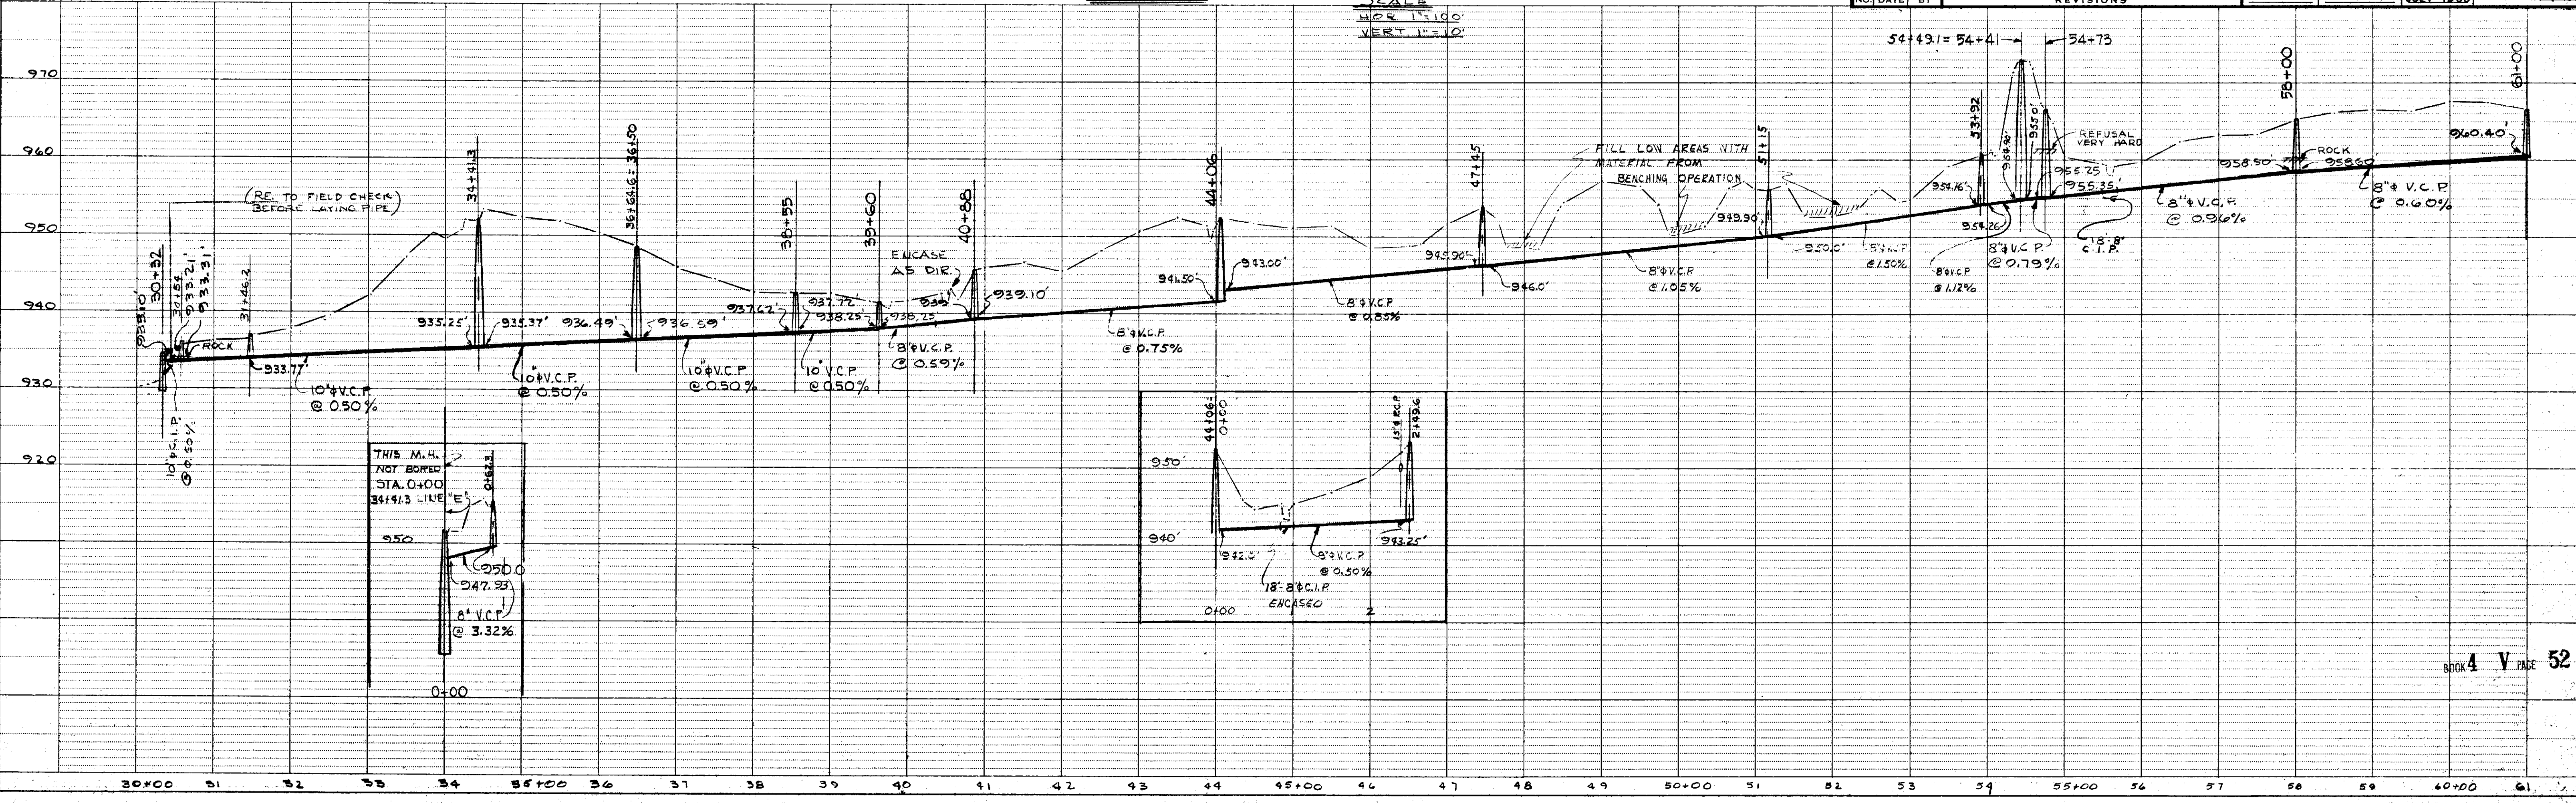

SINGLE PLAN AND PROFILE - DOTTED
H. A. ROGERS CO. - MINNEAPOLIS - ST. PAUL - CHICAGO