



FED. ROAD DIST. No.	STATE	FEDERAL PROJ. No.	FISCAL YEAR	SHEET No.	TOTAL SHEETS

PLAN
 DATE
 BY
 CHECKED
 DATE
 BY

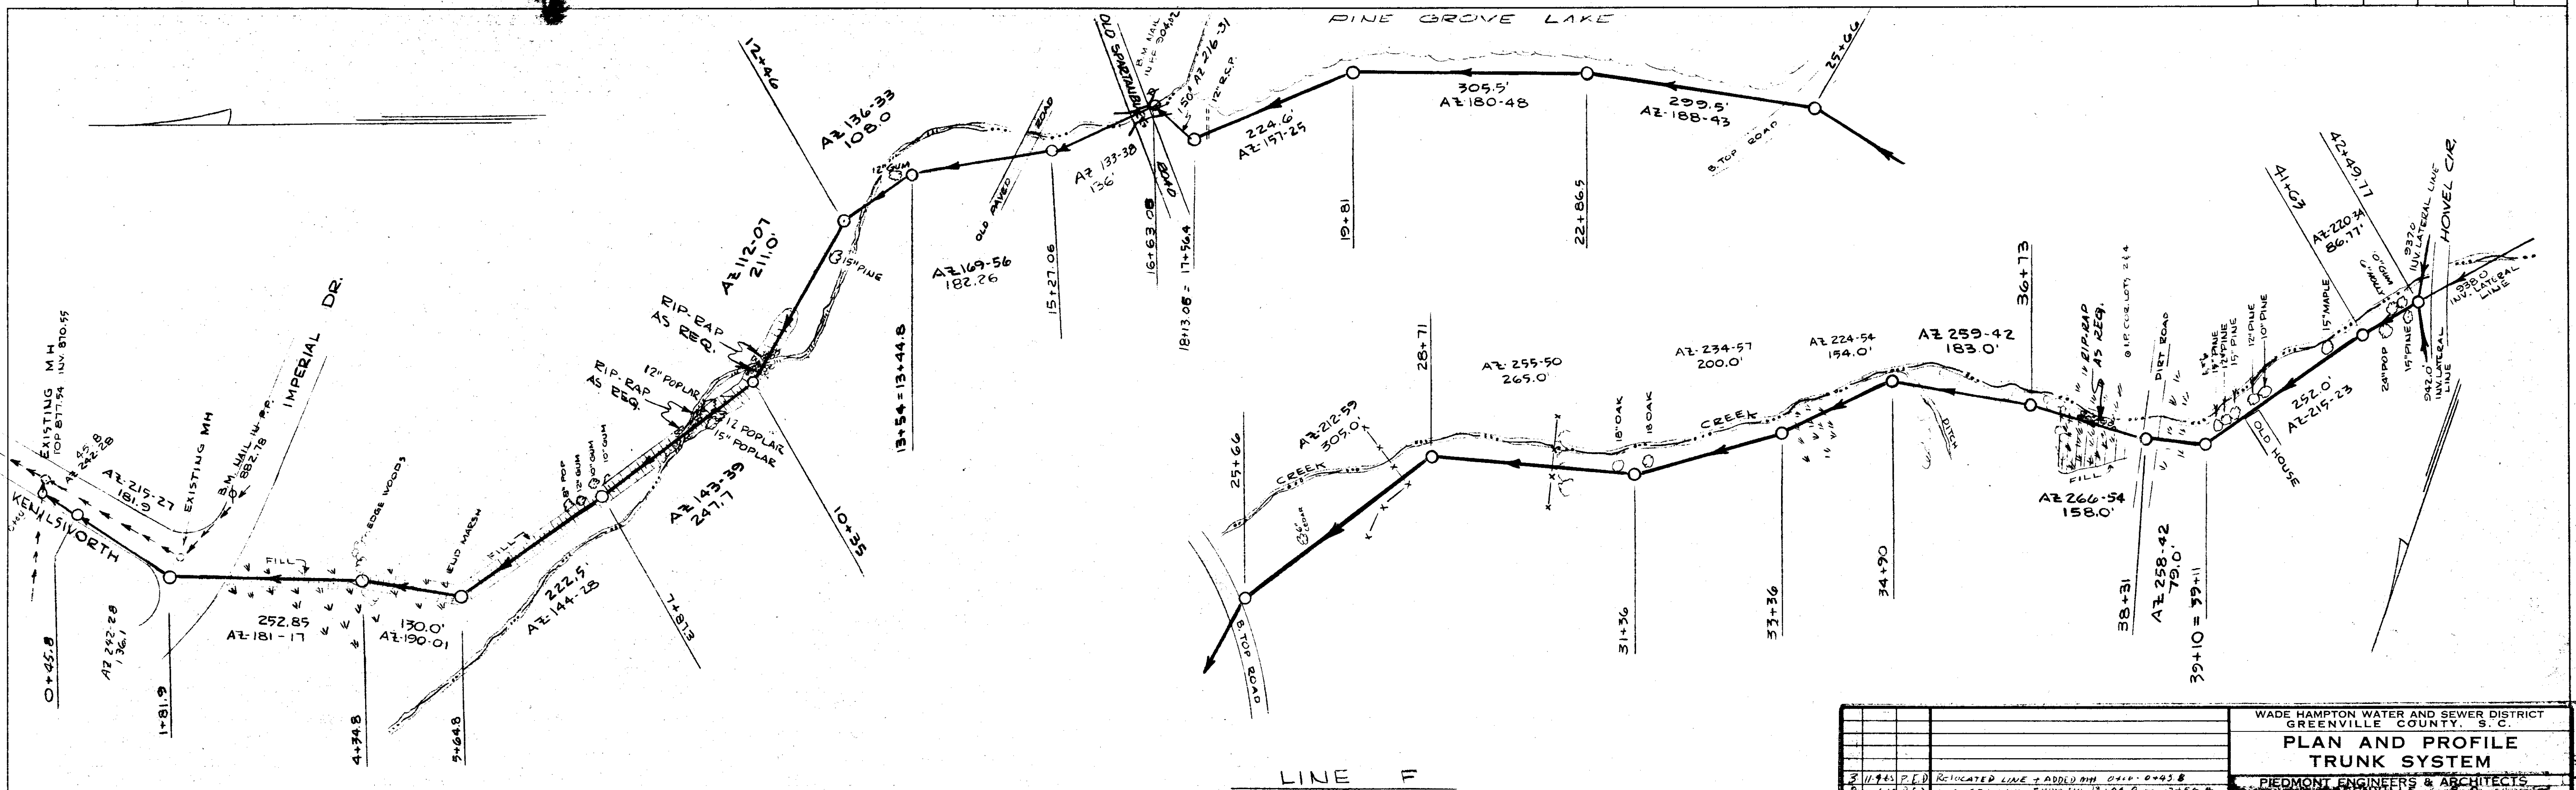

3-11-43 P.E.D.		RELOCATED LINE + ADDED 0+00 TO 0+43.8	WADE HAMPTON WATER AND SEWER DISTRICT GREENVILLE COUNTY S.C.	PIEDMONT ENGINEERS & ARCHITECTS GREENVILLE S.C.
2-11-43 P.D.		CHANGED LINE FROM STA 13+44.8 TO 17+56.4		
1-9-21 P.E.N.		FROM STA 7+87.3 TO 15+30.3 & 24+30 TO 39+11	DRAWN BY	CHECKED BY
NO. DATE BY		REVISIONS	REM	RD
			DATE	DWG. No.
			7-28-65	51

PROFILE
 DATE
 BY
 CHECKED
 DATE
 BY

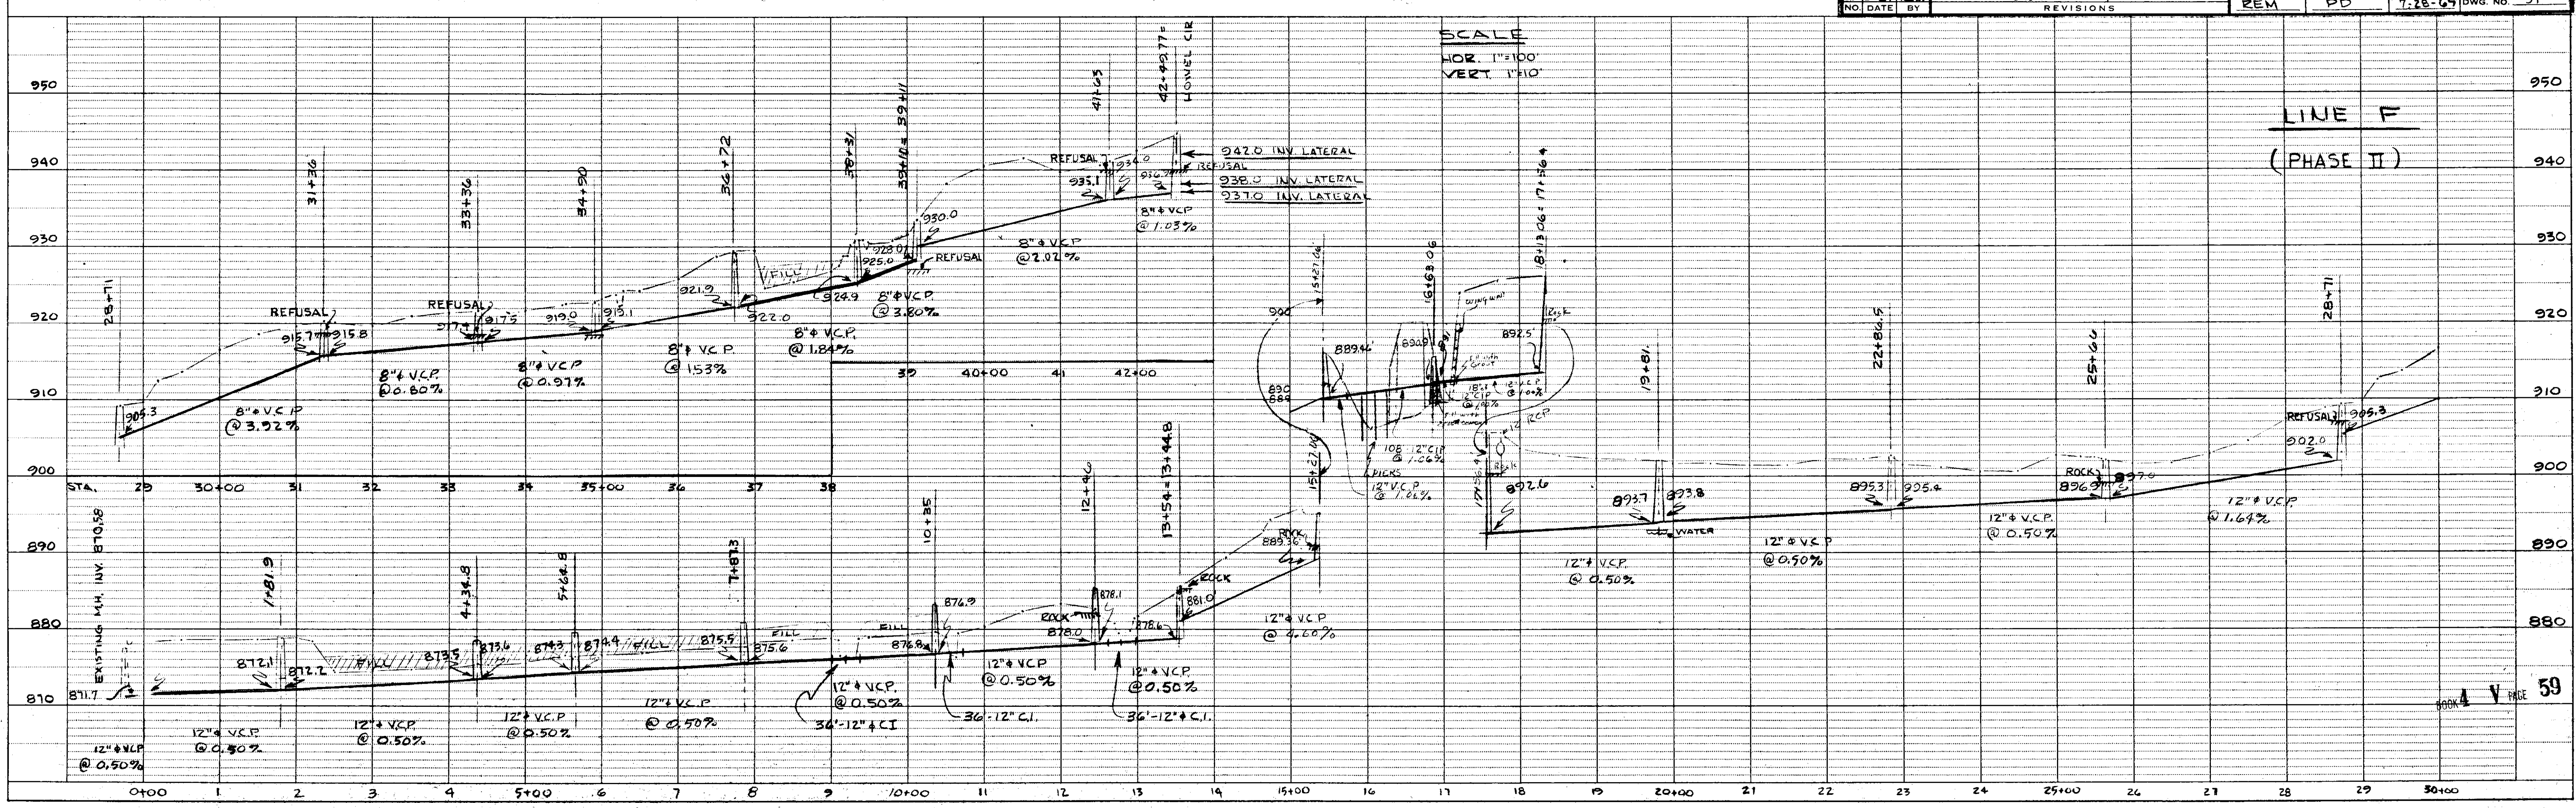

SINGLE PLAN AND PROFILE - DOTTED
 H. A. ROGERS CO. - MINNEAPOLIS - ST. PAUL - DULUTH