




NOTE:  
AERATORS ARE 7.5 HP, 3 PHASE, 60 CYCLE, 220 VOLT

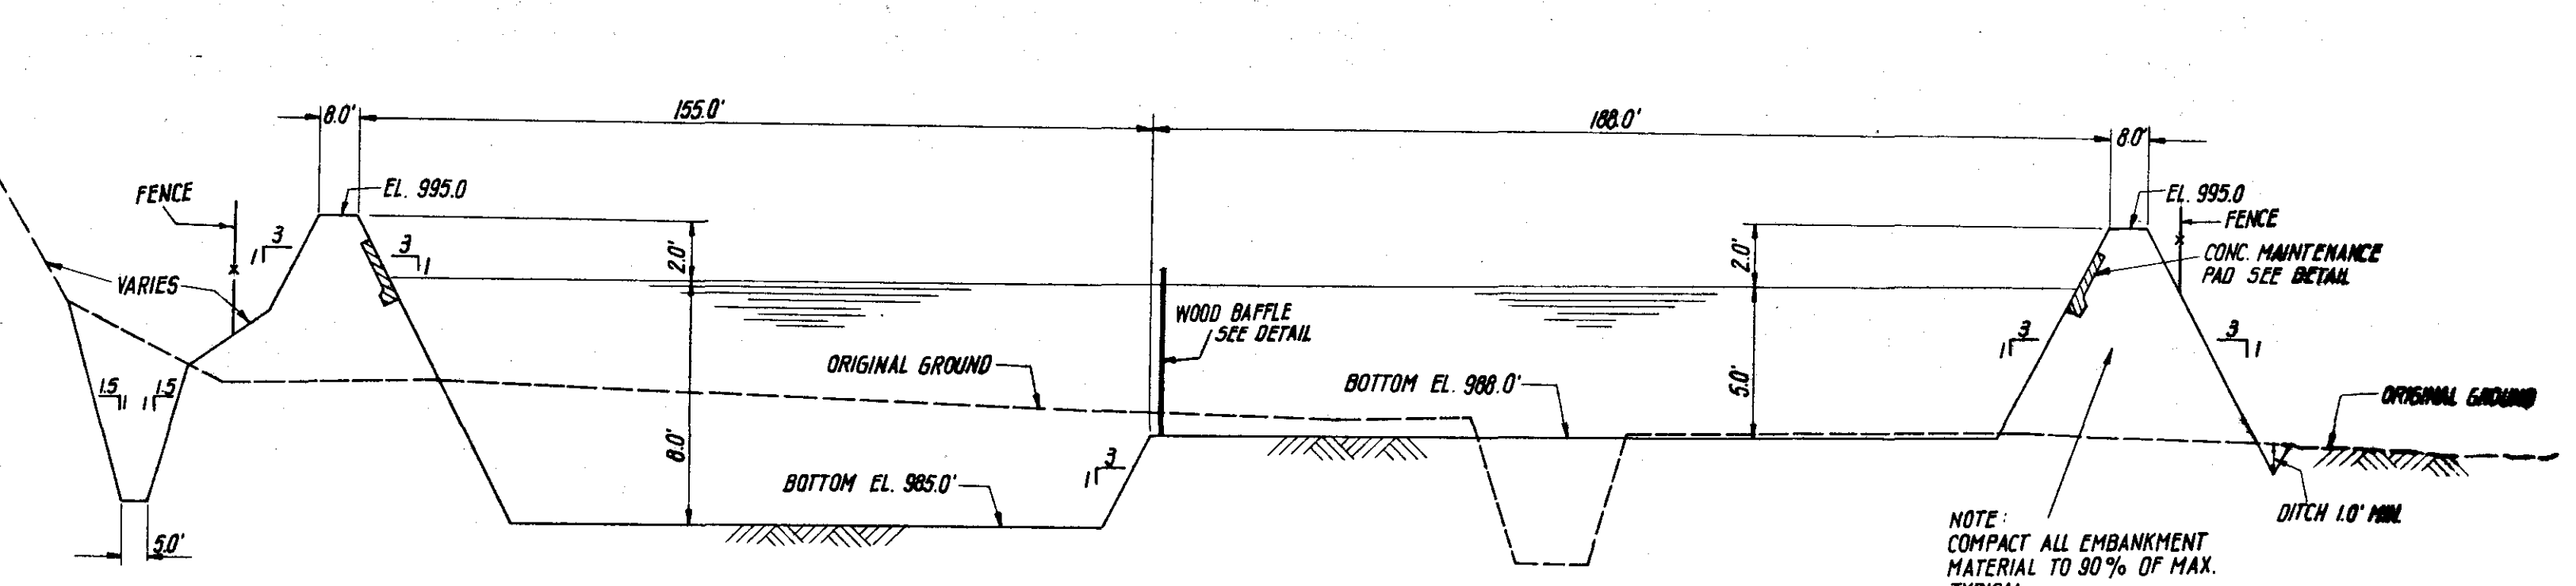

TYPICAL SECTION THRU TREATMENT FACILITY "A-A"  
SCALE: 1" = 30' HOR.  
1" = 5' VERT.

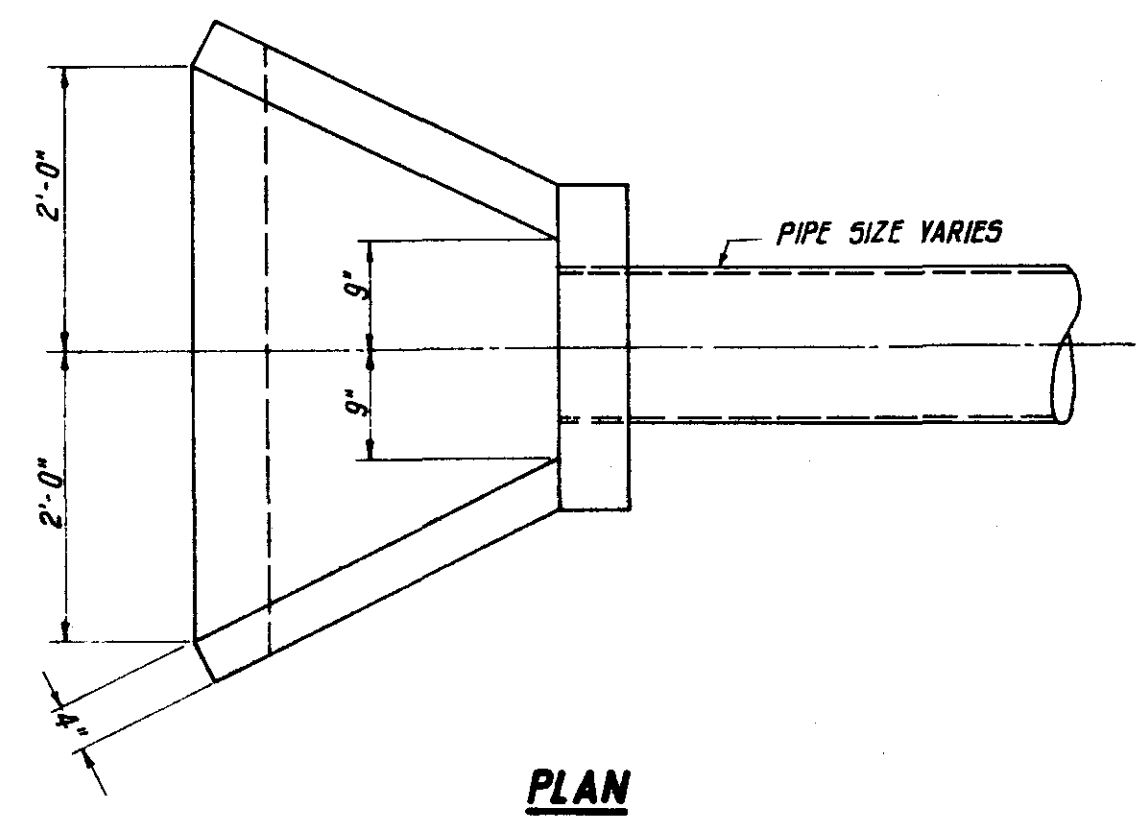

PLAN

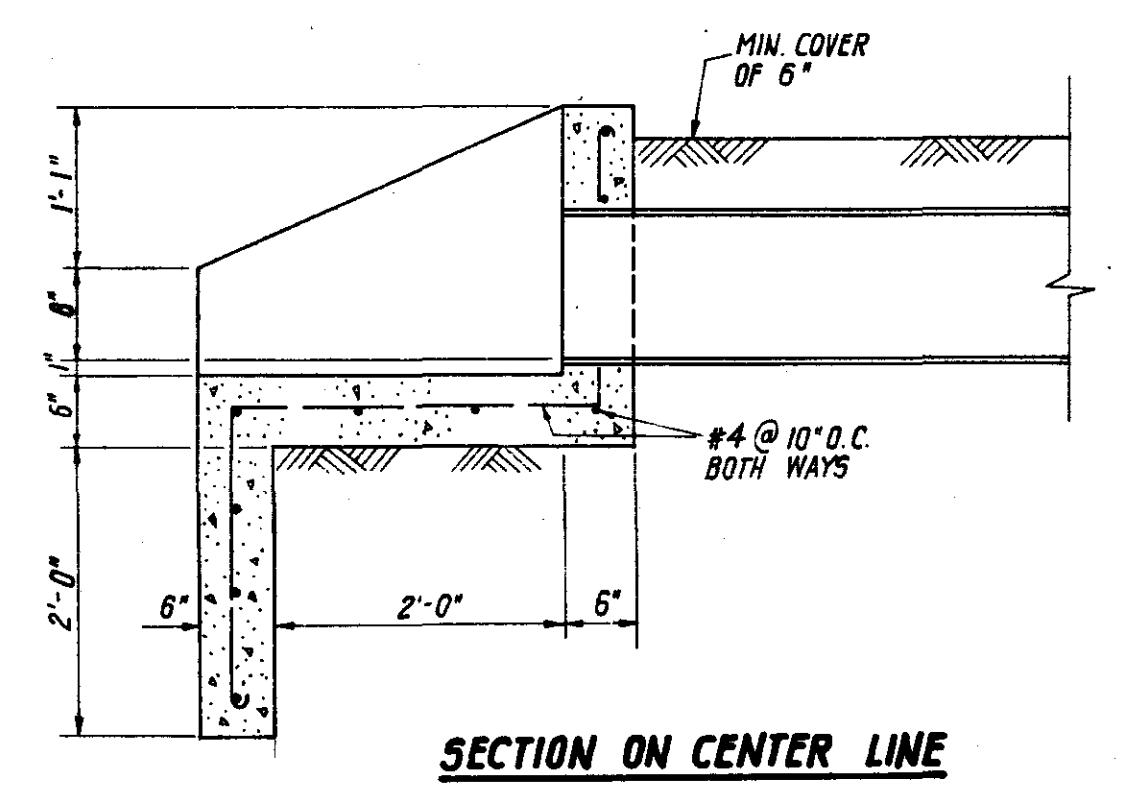

SECTION ON CENTER LINE

HEADWALL DETAIL AT EFFLUENT DISCHARGE

SCALE: 3/4" = 1'-0"

DAVIS AND FLOYD ENGINEERS, INC. CONSULTING ENGINEERS GREENWOOD, S. C.      ATLANTA, GA.	OWNER <b>TOWN OF TRAVELERS REST, S.C.</b>	TITLE <b>EAST LAGOON GRADING PLAN</b>		DESIGNED: P.R.F.	SCALE: 1" = 30'	CONTRACT NO. 294
		DRAWN: G.F.	CHECKED:	DATE: JULY 1968	SH. 19 OF 43	
		APPROVED:	DATE:	REVISIONS:	BY:	
					APPROVED:	