



PLAN

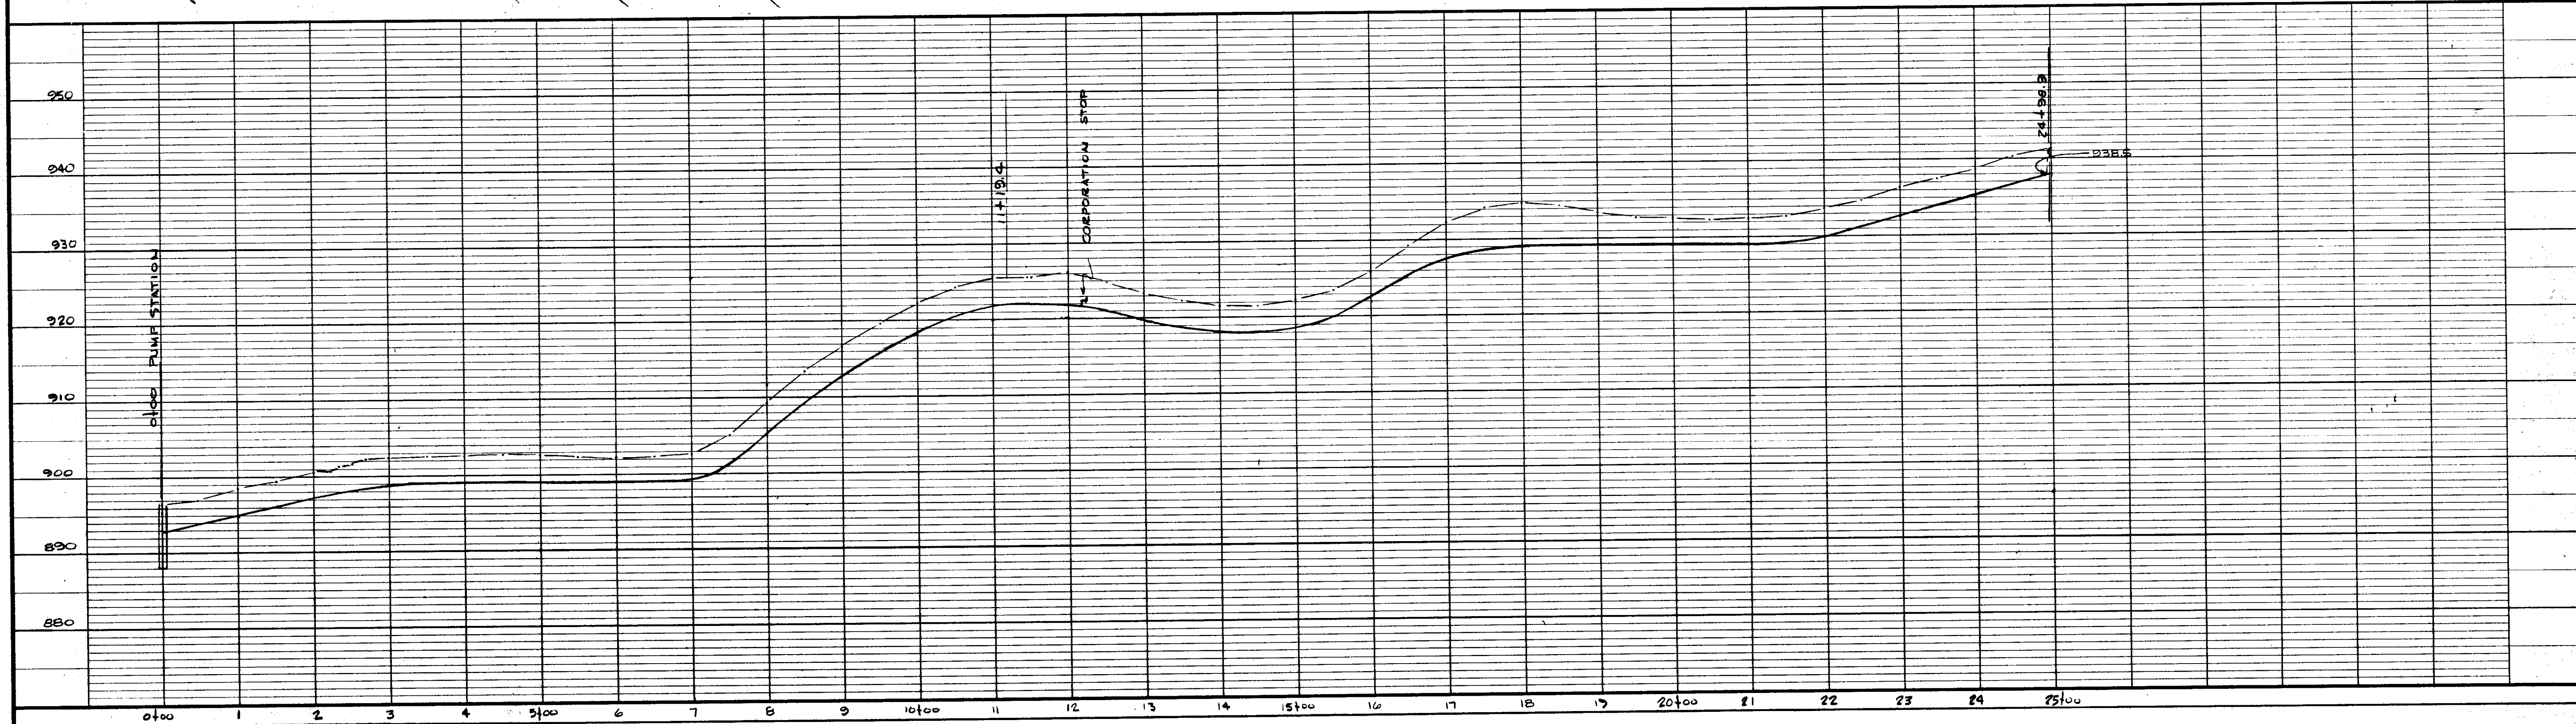


PROFILE

BOOK 4 V PAGE 109

NO.	DATE	BY	REVISIONS DESCRIPTION
1	10/12/66	RC	REMOVED HOLD

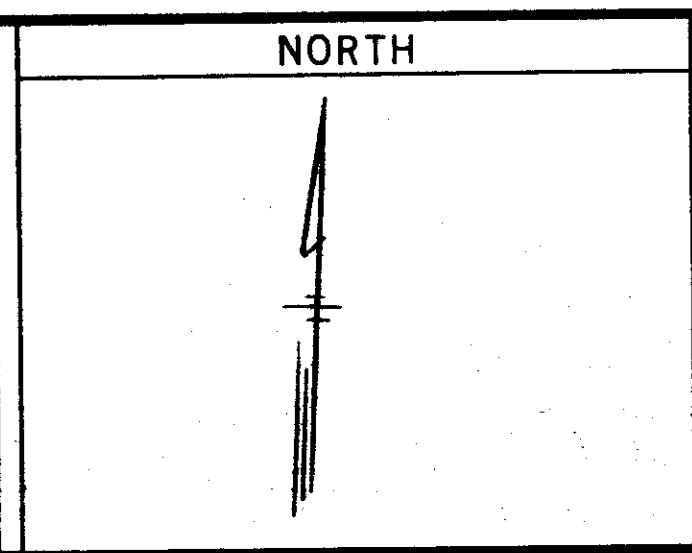

SCALE
 HORIZONTALLY
 1" = 100'
 VERTICALLY
 1" = 10'

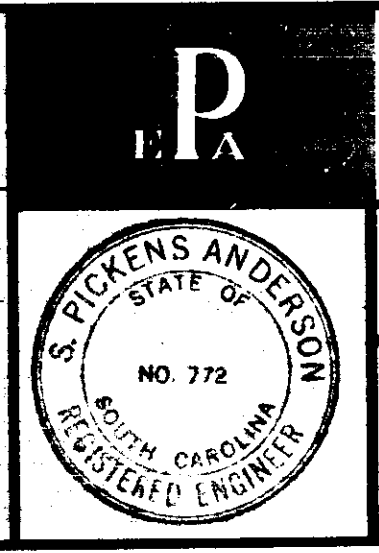

TOWN OF MAULDIN
 GREENVILLE COUNTY, S. C.
 PUMP STATIONS & FORCE MAIN
 PLAN AND PROFILE
 BISHOP HEIGHTS FORCE MAIN
 PIEDMONT
 ENGINEERS & ARCHITECTS
 420 PARK AVE., GREENVILLE, S.C.

SHEET NO.
6-A
 DWN R.E.M.
 CKD T.T.
 APPD
 JOB 2 0020
 DATE 6-23-67