



REVISIONS	
NO.	DATE BY DESCRIPTION
1	1/24/72 RLC REVISED "L" 35+68 TO 44+44 C'-L-B"
2	1/24/72 RLC REVISED "L" 56+17 TO 59+37 ADDED HOLD

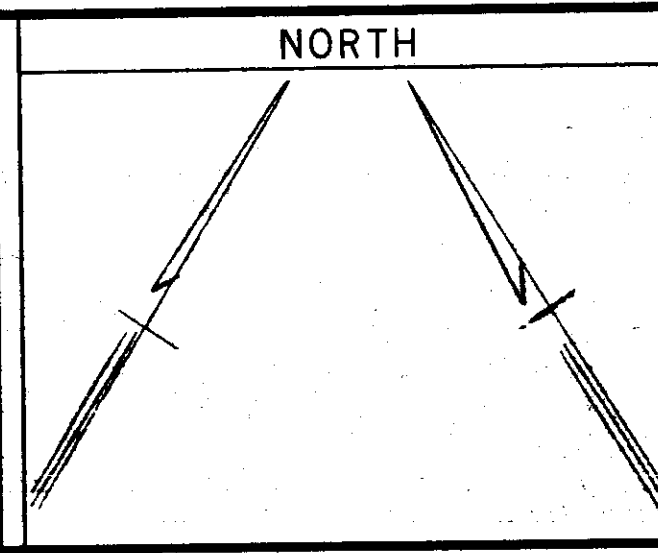

SCALE

HORIZONTALLY
1" = 100'

VERTICALLY
1" = 10'

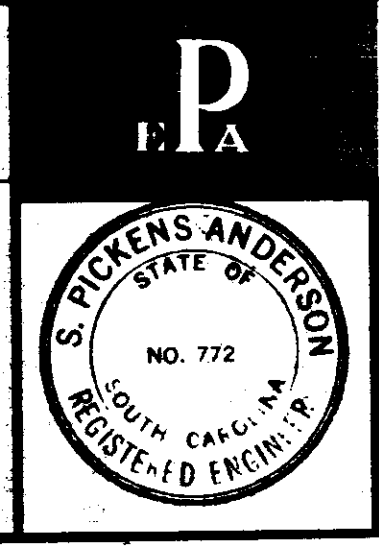

BOOK 4 V PAGE 113
LINES L-1, L-8 & L-9

PROJ. NO. WS-3-41-011

TOWN OF MAULDIN
GREENVILLE COUNTY, S.C.

LAUREL CREEK BASIN
SANITARY SEWERS

PLAN AND PROFILE
INTERCEPTOR SYSTEM

PIEDMONT
ENGINEERS & ARCHITECTS
420 PARK AVE., GREENVILLE, S.C.

SHEET NO.
10

DWN R.L.C.
CKD P.E.D.
APPD
JOB 20020
DATE 4-24-67