


PLAN

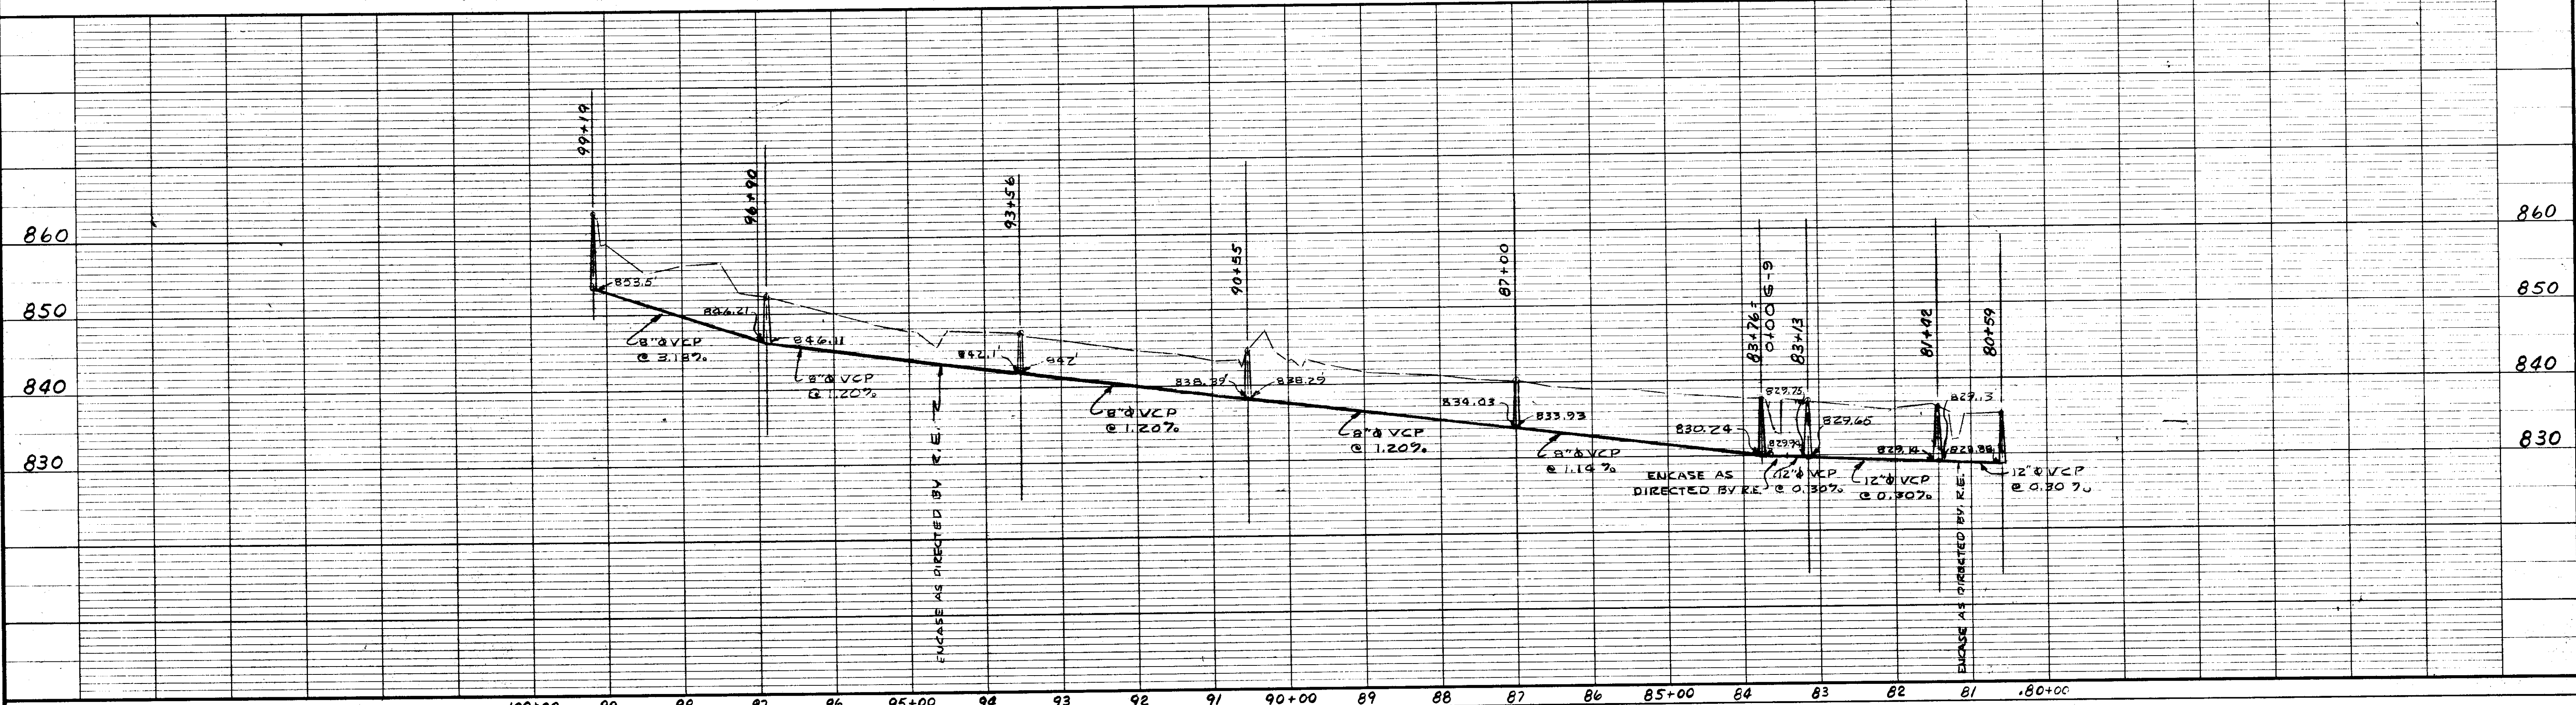


PROFILE


BOOK 4 V PAGE 130

LINE G

| NO. | DATE | BY | REVISIONS DESCRIPTION |
|-----|------|----|-----------------------|
| | | | |
| | | | |
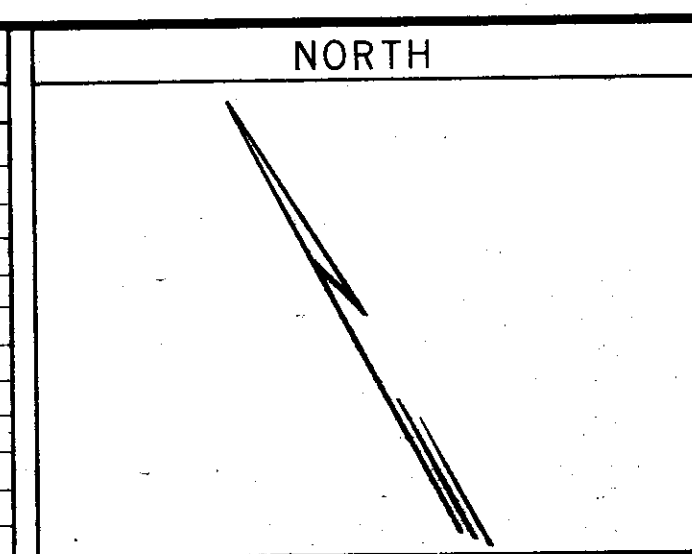

SCALE
 HORIZONTALLY
 1" = 100'
 VERTICALLY
 1" = 10'

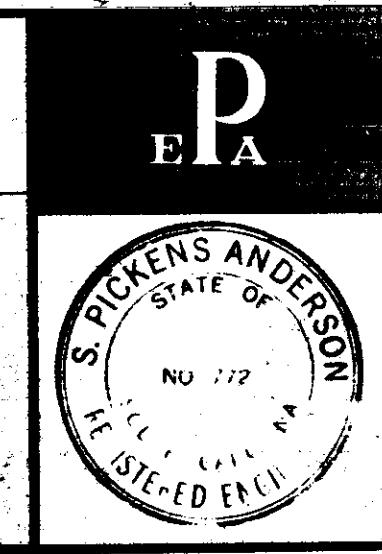

TOWN OF MAULDIN
 GREENVILLE COUNTY, S. C.
 GILDER CREEK BASIN
 SANITARY SEWERS
 PLAN AND PROFILE
 INTERCEPTOR SYSTEM
 PIEDMONT
 ENGINEERS & ARCHITECTS
 420 PARK AVE., GREENVILLE, S.C.

| | |
|------------|------------|
| SHEET NO. | 34 |
| DWN R.L.C. | CKD P.E.D. |
| APPD | JOB 20020 |
| DATE | 4-24-67 |