



PLAN

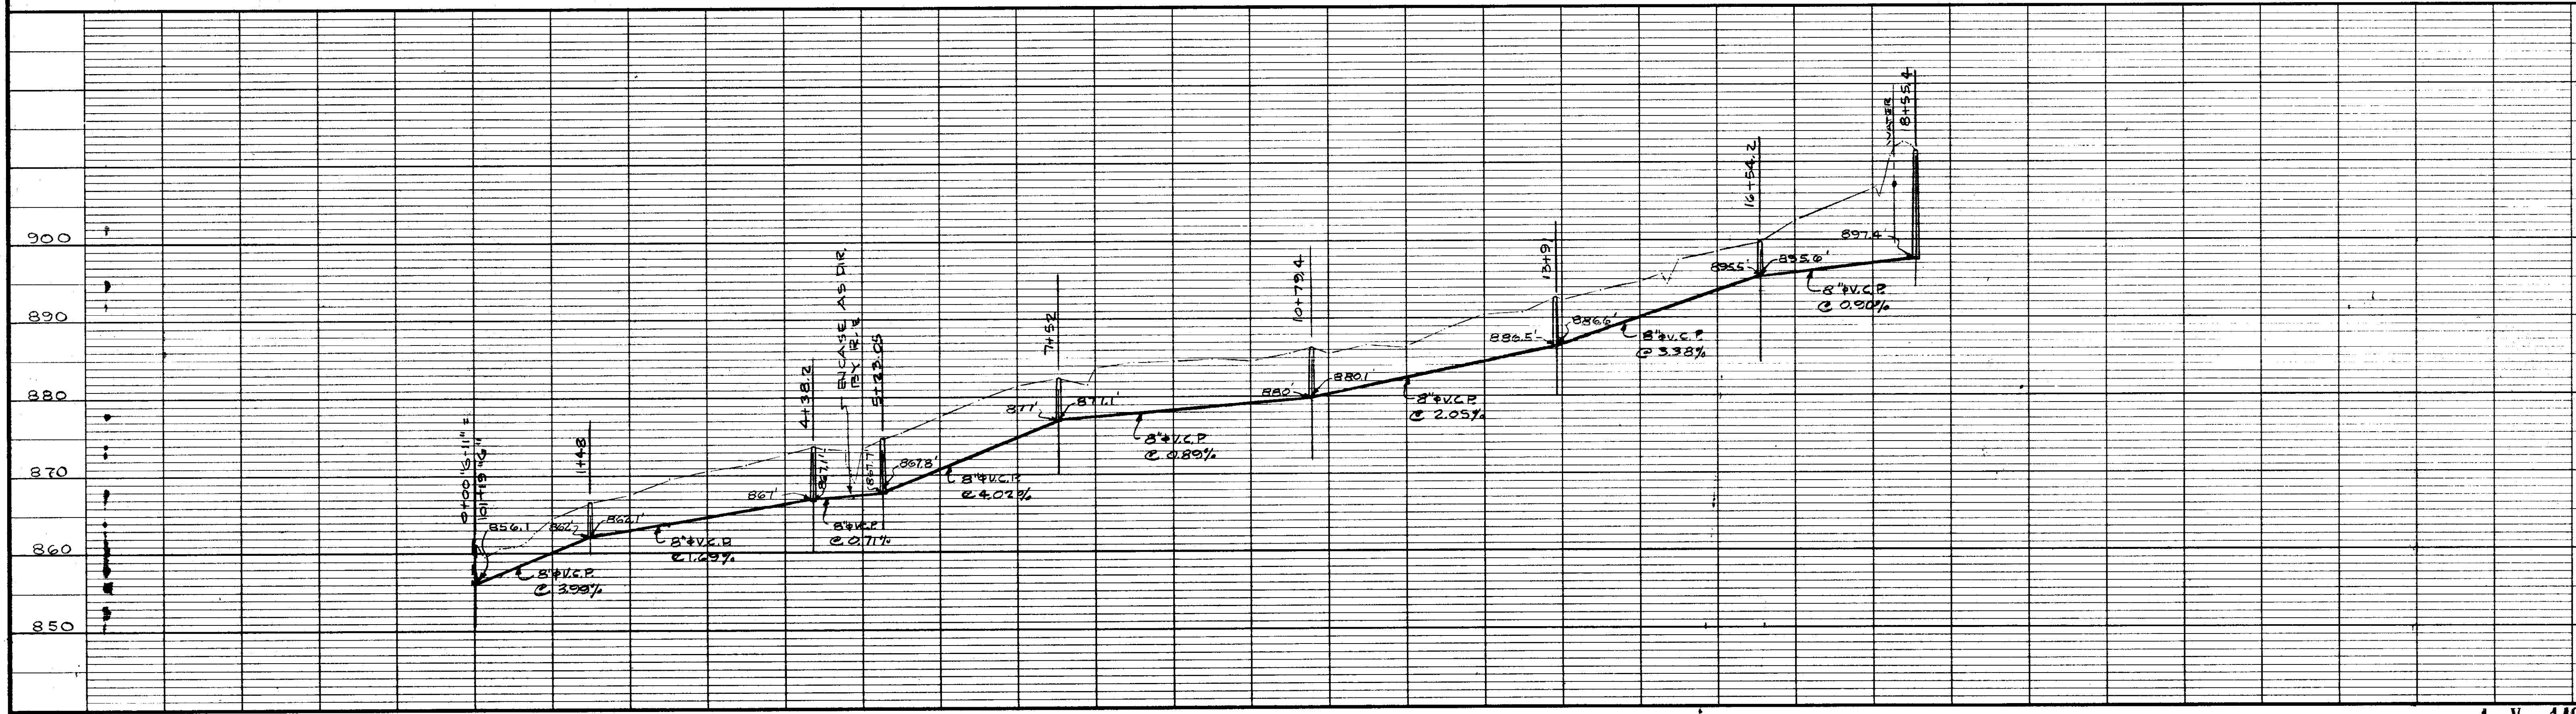


PROFILE

BOOK 4 V PAGE 140

REVISIONS	
NO.	DATE BY DESCRIPTION

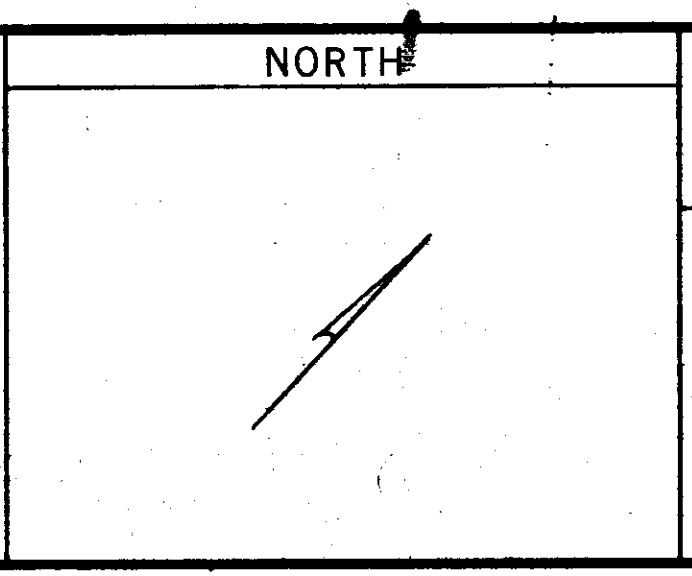

SCALE
 HORIZONTALLY
 1" = 100'
 VERTICALLY
 1" = 10'

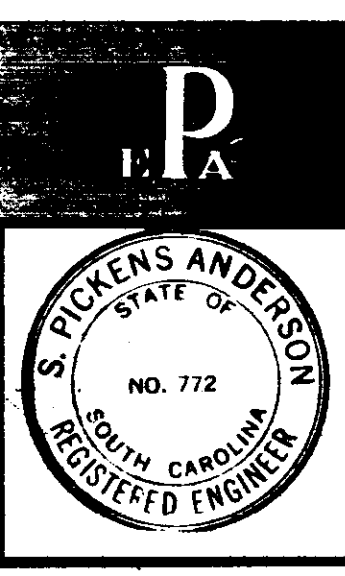

PROJ. NO. WS-3-41-011 LINE G-11

TOWN OF MAULDIN
 GREENVILLE COUNTY, S.C.
 GILDER CREEK BASIN
 SANITARY SEWERS

PLAN AND PROFILE
 INTERCEPTOR SYSTEM

PIEDMONT
 ENGINEERS & ARCHITECTS
 420 PARK AVE., GREENVILLE, S.C.

SHEET NO.
44

DWN R.L.C.
 CKD P.E.D.
 APPD
 JOB 20020
 DATE 4-24-67