



NO	DATE	REVISION	BY


FILED  
GREENVILLE CO. S. C.  
APR 27 12 02 PM '73  
DONNIE S. TANKERSLEY  
R.M.C.

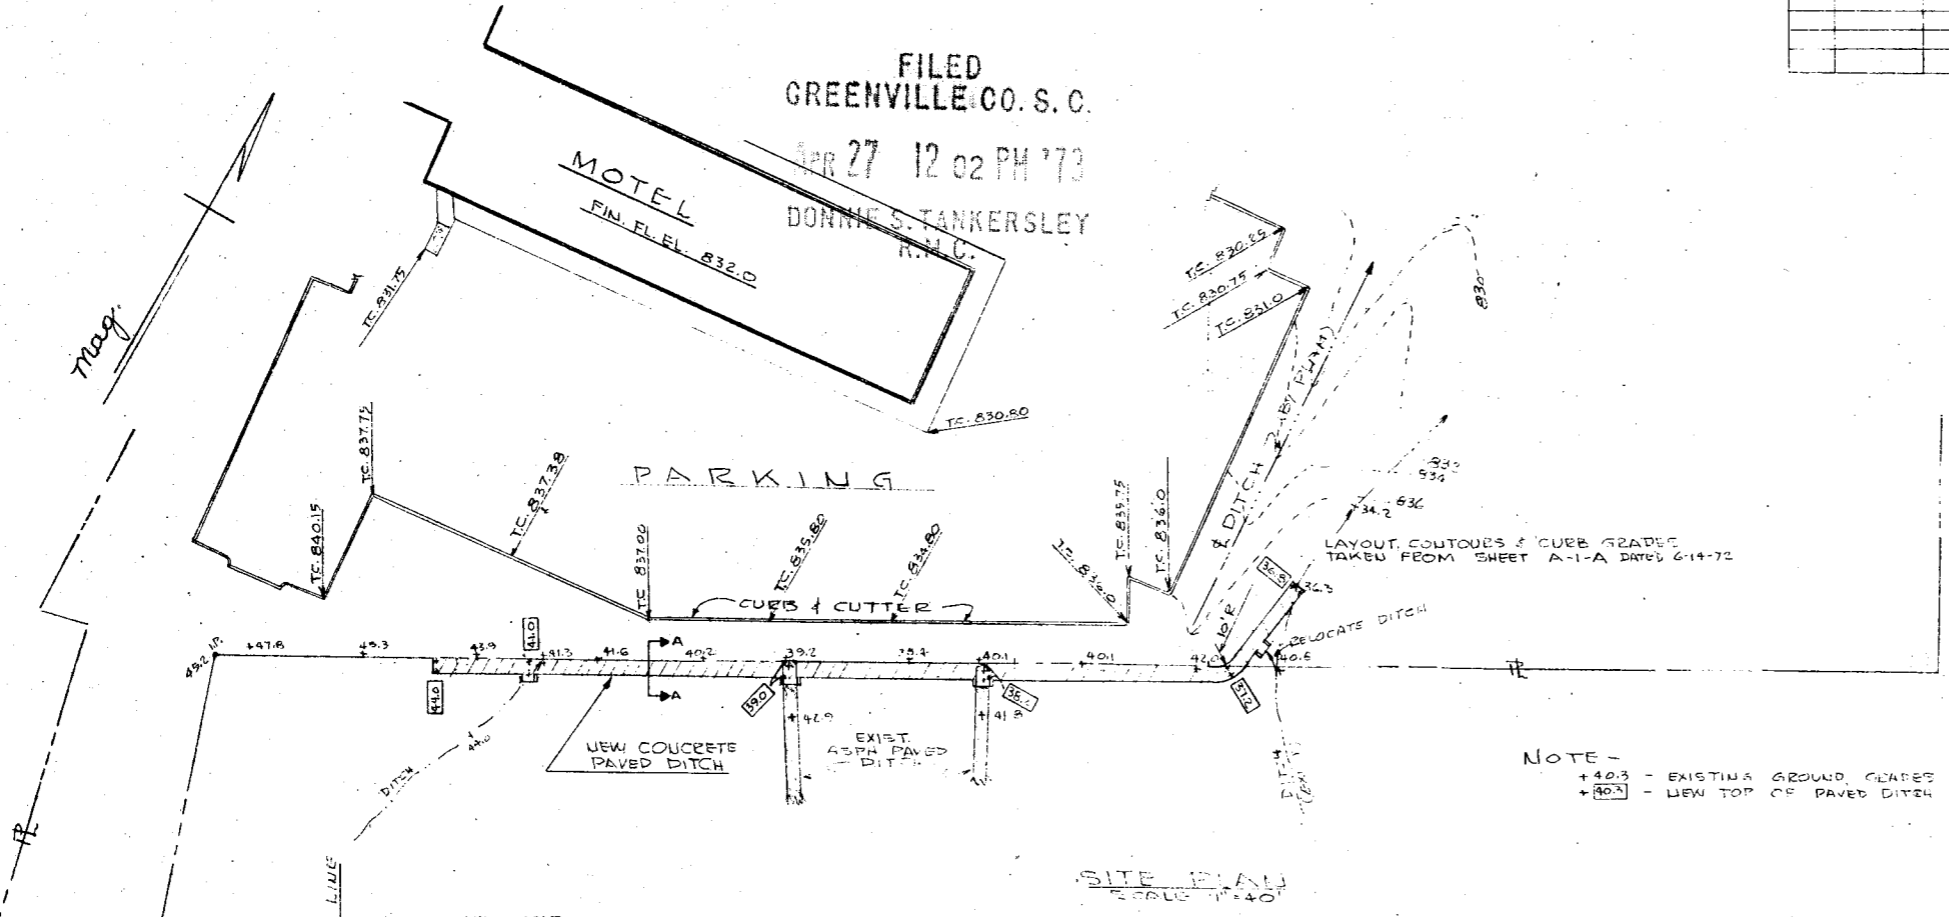

SITE PLAN  
SCALE 1"=40'

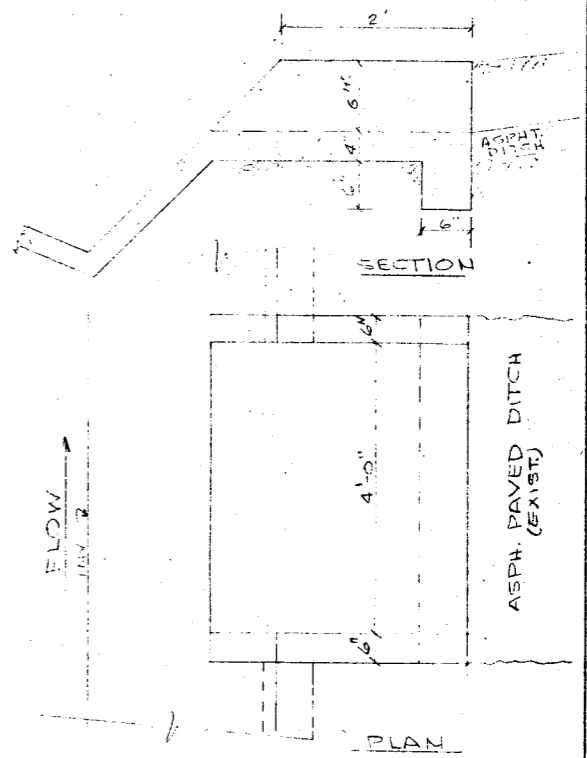

DETAIL OF TIE-IN OF ASPH. PAVED  
DITCH TO CONCRETE PAVED DITCH.  
N/S

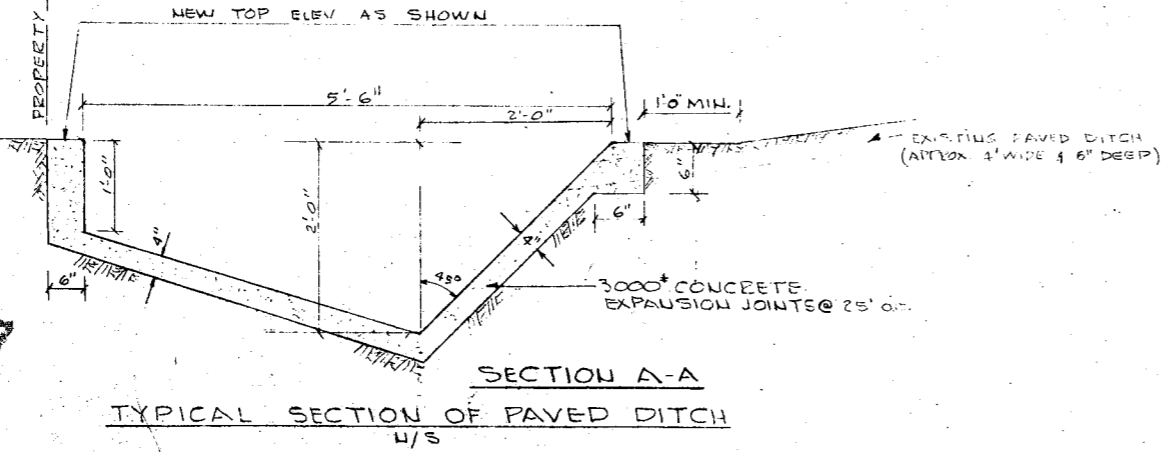

4Z-20

RECORDING FEE  
160

30457

P	SHERATON MOTEL BUILDING GREENVILLE, S.C.	1 OF 1
	PAVED DRAINAGE DITCH	DWN D.S.C. CKD
	PIEDMONT ENGINEERS & ARCHITECTS 420 PARK AVE, GREENVILLE, S.C.	APPD JOB DATE 9-25-72