



FILED  
GREENVILLE, S.C.  
AUG 13 9 45 AM 1962  
G.W. BOONE

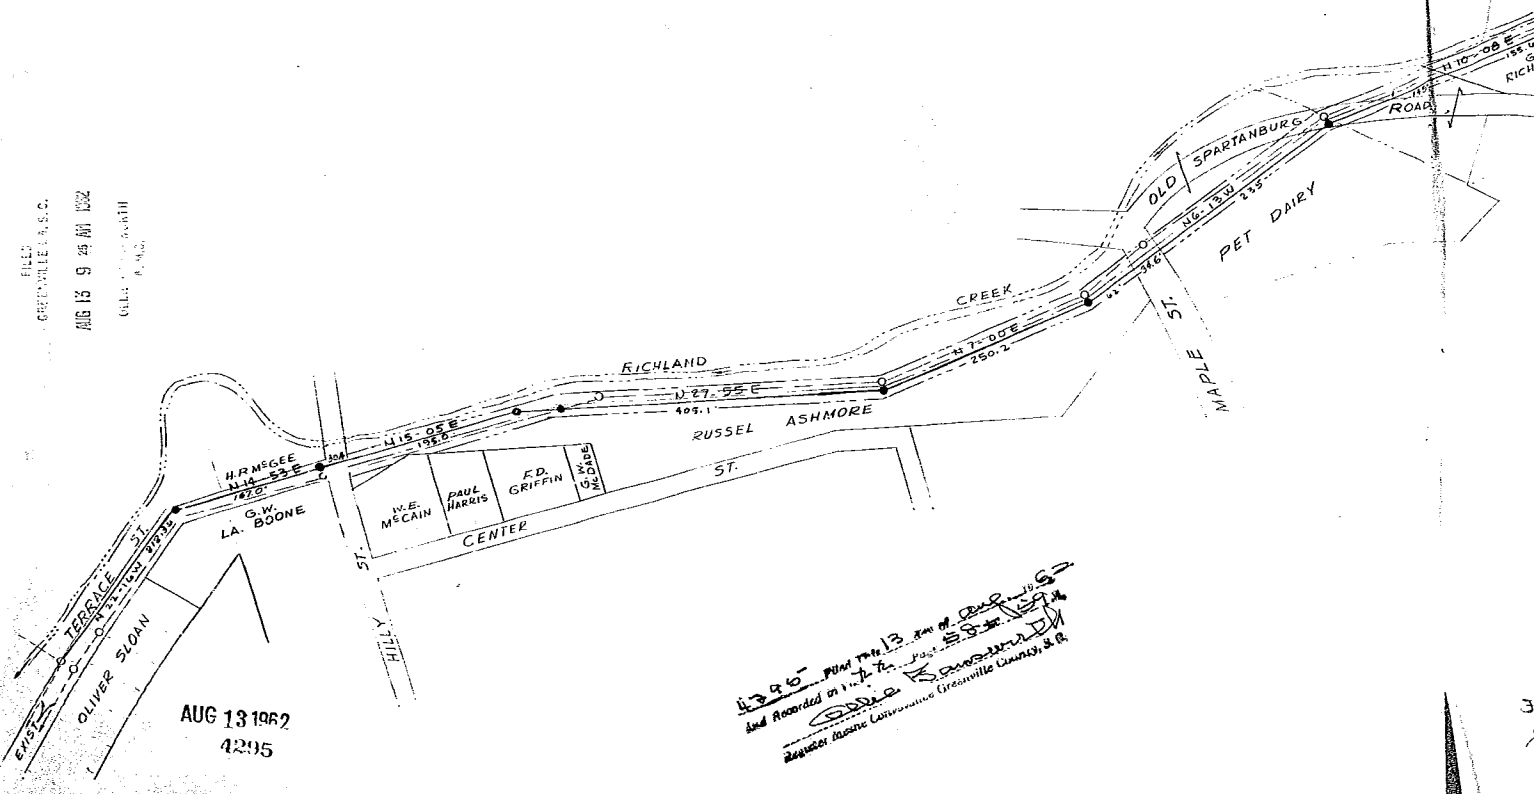


1390 - ROAD FROM 13<sup>th</sup> ST. TO 15<sup>th</sup> ST.  
And Recorded on 11/1/62  
G.W. BOONE  
Register of Deeds Greenville County, S.C.

X X - 58 + 59 Sec & 4.00

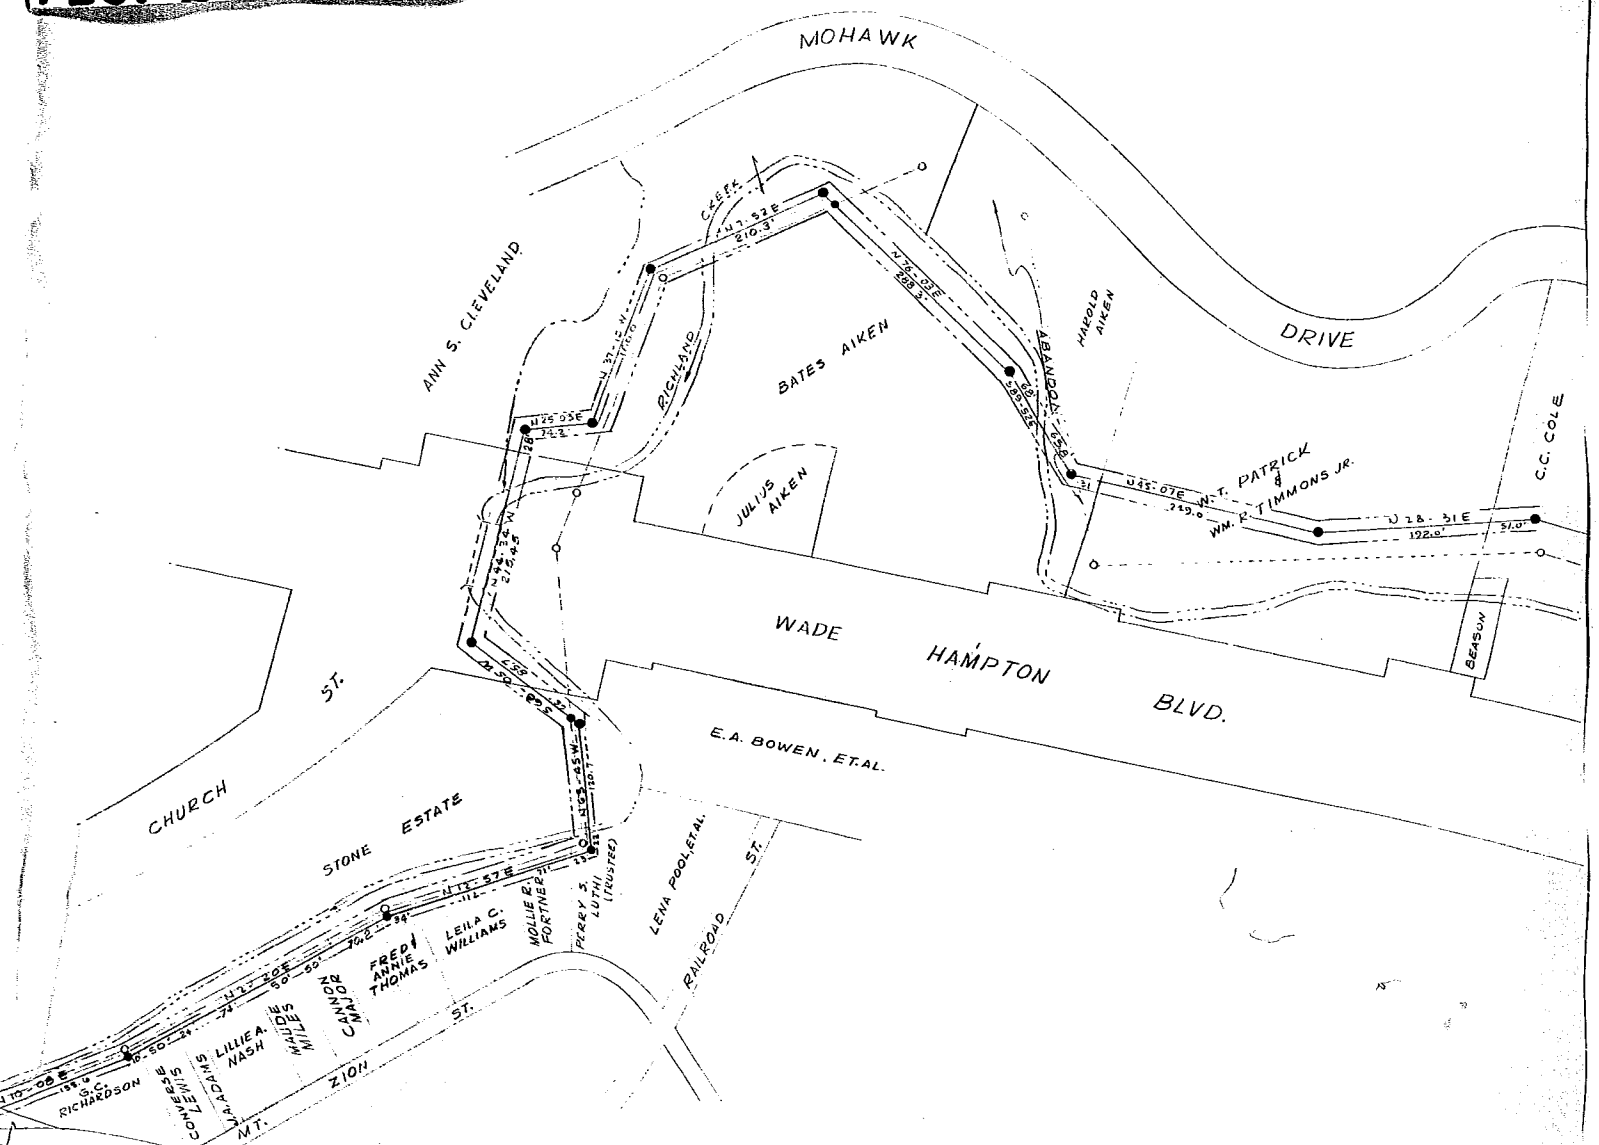

**LEGEND**

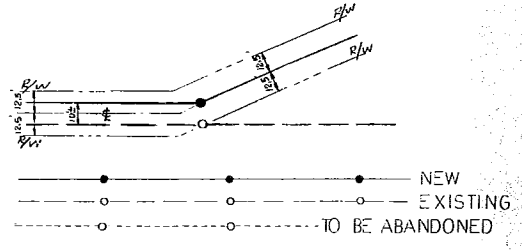

NOTE -  
 ① DISTANCES SHOWN ACROSS PROPERTY SCALED FROM THIS DWG. AND ARE ALL PLUS OR MINUS.  
 ② PROPERTY INFORMATION TAKEN FROM COUNTY BLOCK BOOK AND HAS NOT BEEN VERIFIED IN THE FIELD.

PROPERTY OWNERSHIP MAP	
<b>RICHLAND CREEK RELIEF SEWER</b>	
PIEDMONT ENGINEERING SERVICE GREENVILLE, SOUTH CAROLINA	
SCALE 1"=100'	DATE MAY 28, 1962
DRAWN BY DDC	CHECKED BY DSC
APPROVED	DWG. NO. 1 OF 3

For Revised and corrected Plat see Plat Book XX Pages 120 + 121

NO.	DATE	BY	REVISIONS
1	7-30-62	DSC	COURSE & DIST. ACROSS PROPERTY

**BAD COPY**