



PLAN	SURVEYED	BY	DATE
	ALIGNED		
	RT. OF WAY CHECKED		
	NO.		

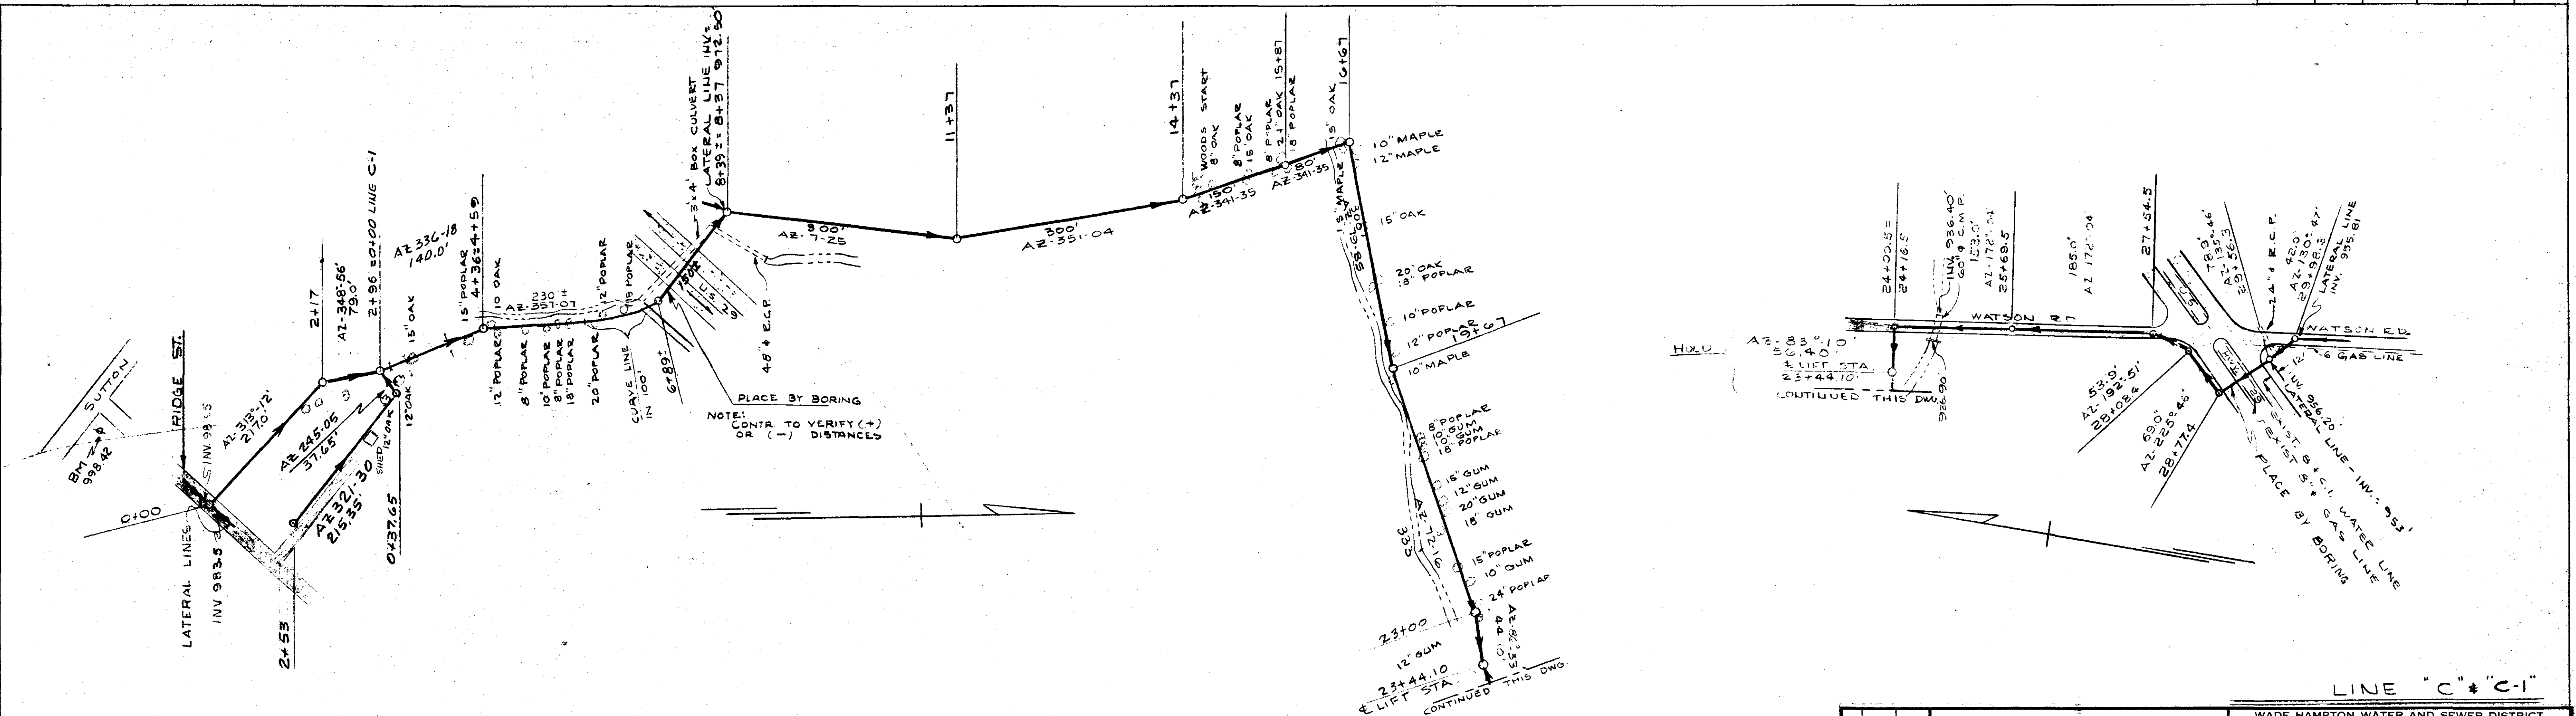

PROFILE	SURVEYED	BY	DATE
	GRADES CHECKED		
	B.M.'S NOTED		
	STRUCTURE NOTATIONS CHKD		
	NO.		

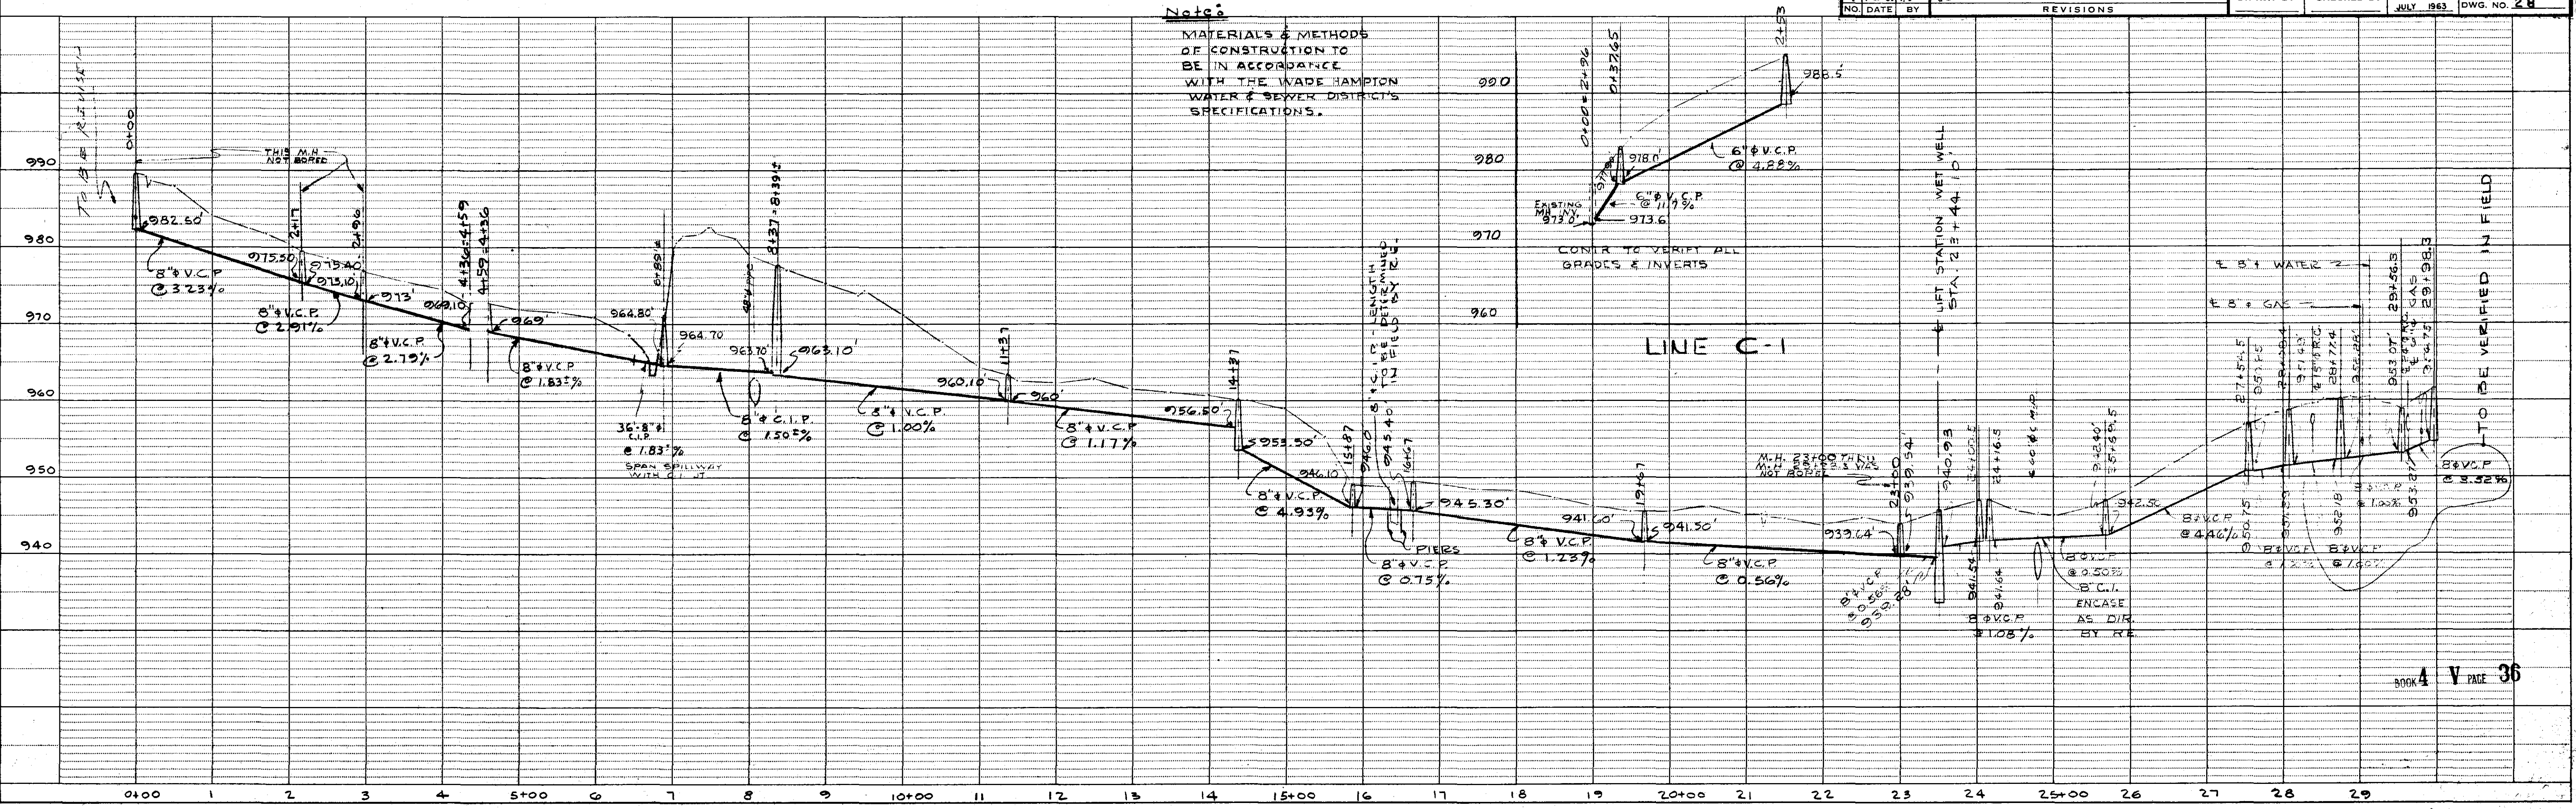

3	8-15	REN	ADD LINE C-1
2	11-14	PI D	REVISED FROM STA 4+59 - 8+37
1	9-23	PD	GENERAL
NO.	DATE	BY	REVISIONS

WADE HAMPTON WATER AND SEWER DISTRICT  
GREENVILLE COUNTY, S. C.  
**PLAN AND PROFILE**  
**TRUNK SYSTEM**  
PIEDMONT ENGINEERING SERVICE  
GREENVILLE, S. C.  
DRAWN BY: \_\_\_\_\_ CHECKED BY: \_\_\_\_\_ DATE: JULY 1963 DWG. NO. 28