
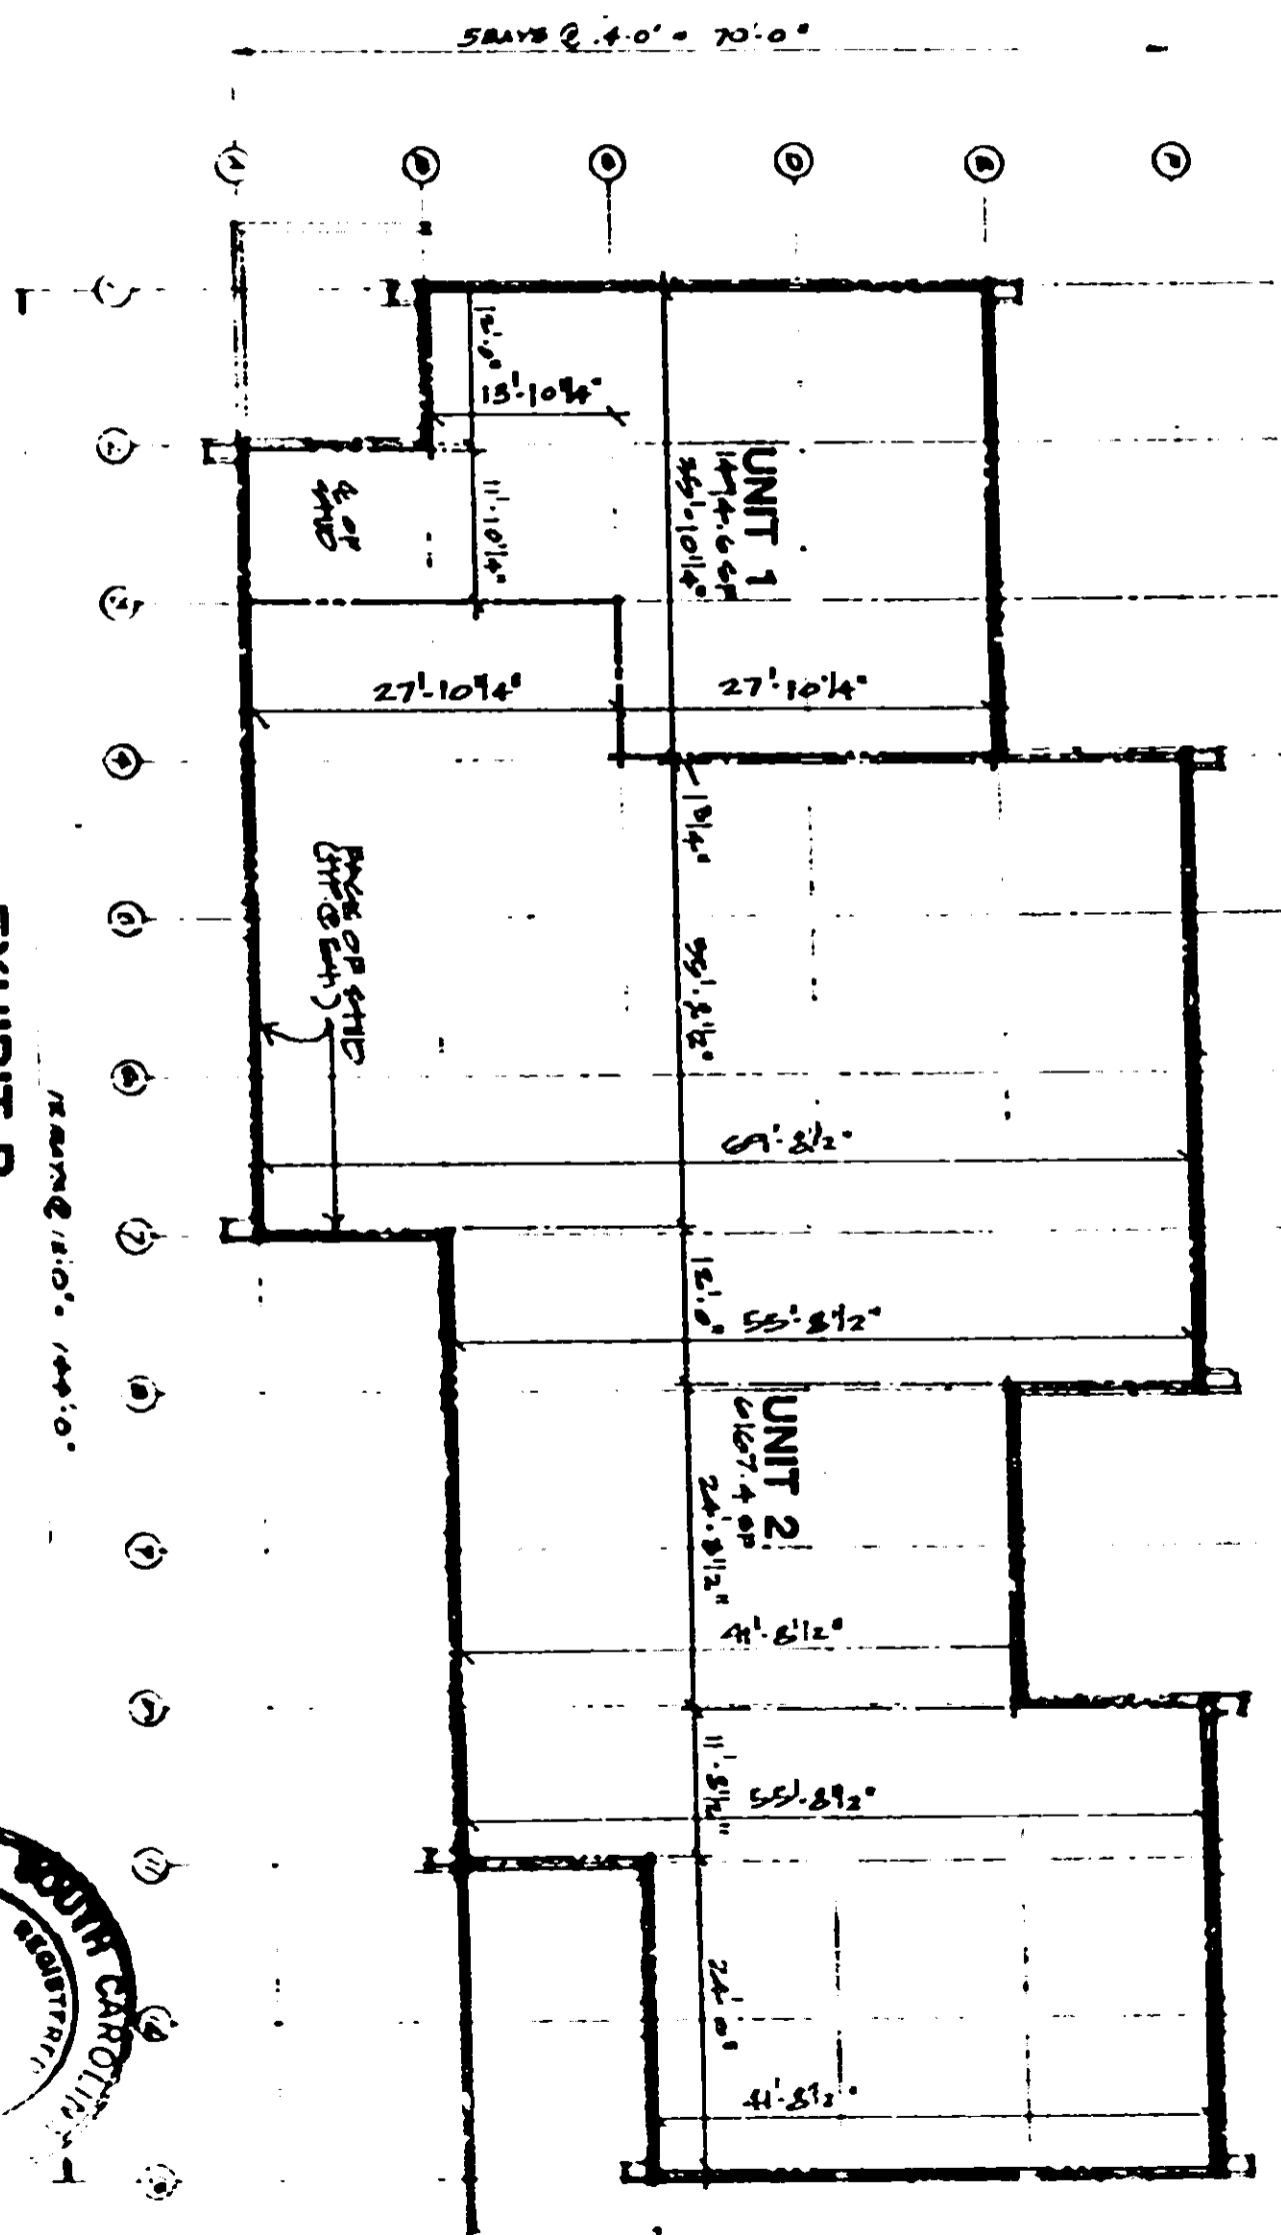


1111  
K B E B



**EXHIBIT B**  
LOWER LEVEL FLOOR PLAN  
 SCALE 1/8" = 1'-0"  
 PHYSICIANS CENTER  
 GREENVILLE, S.C.

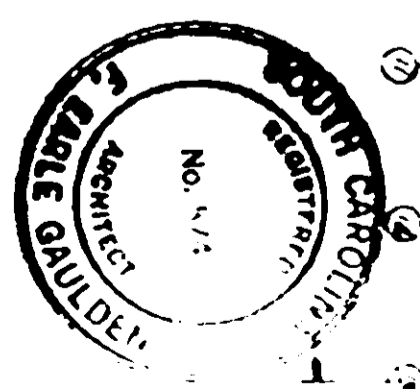

1111  
K B E B